


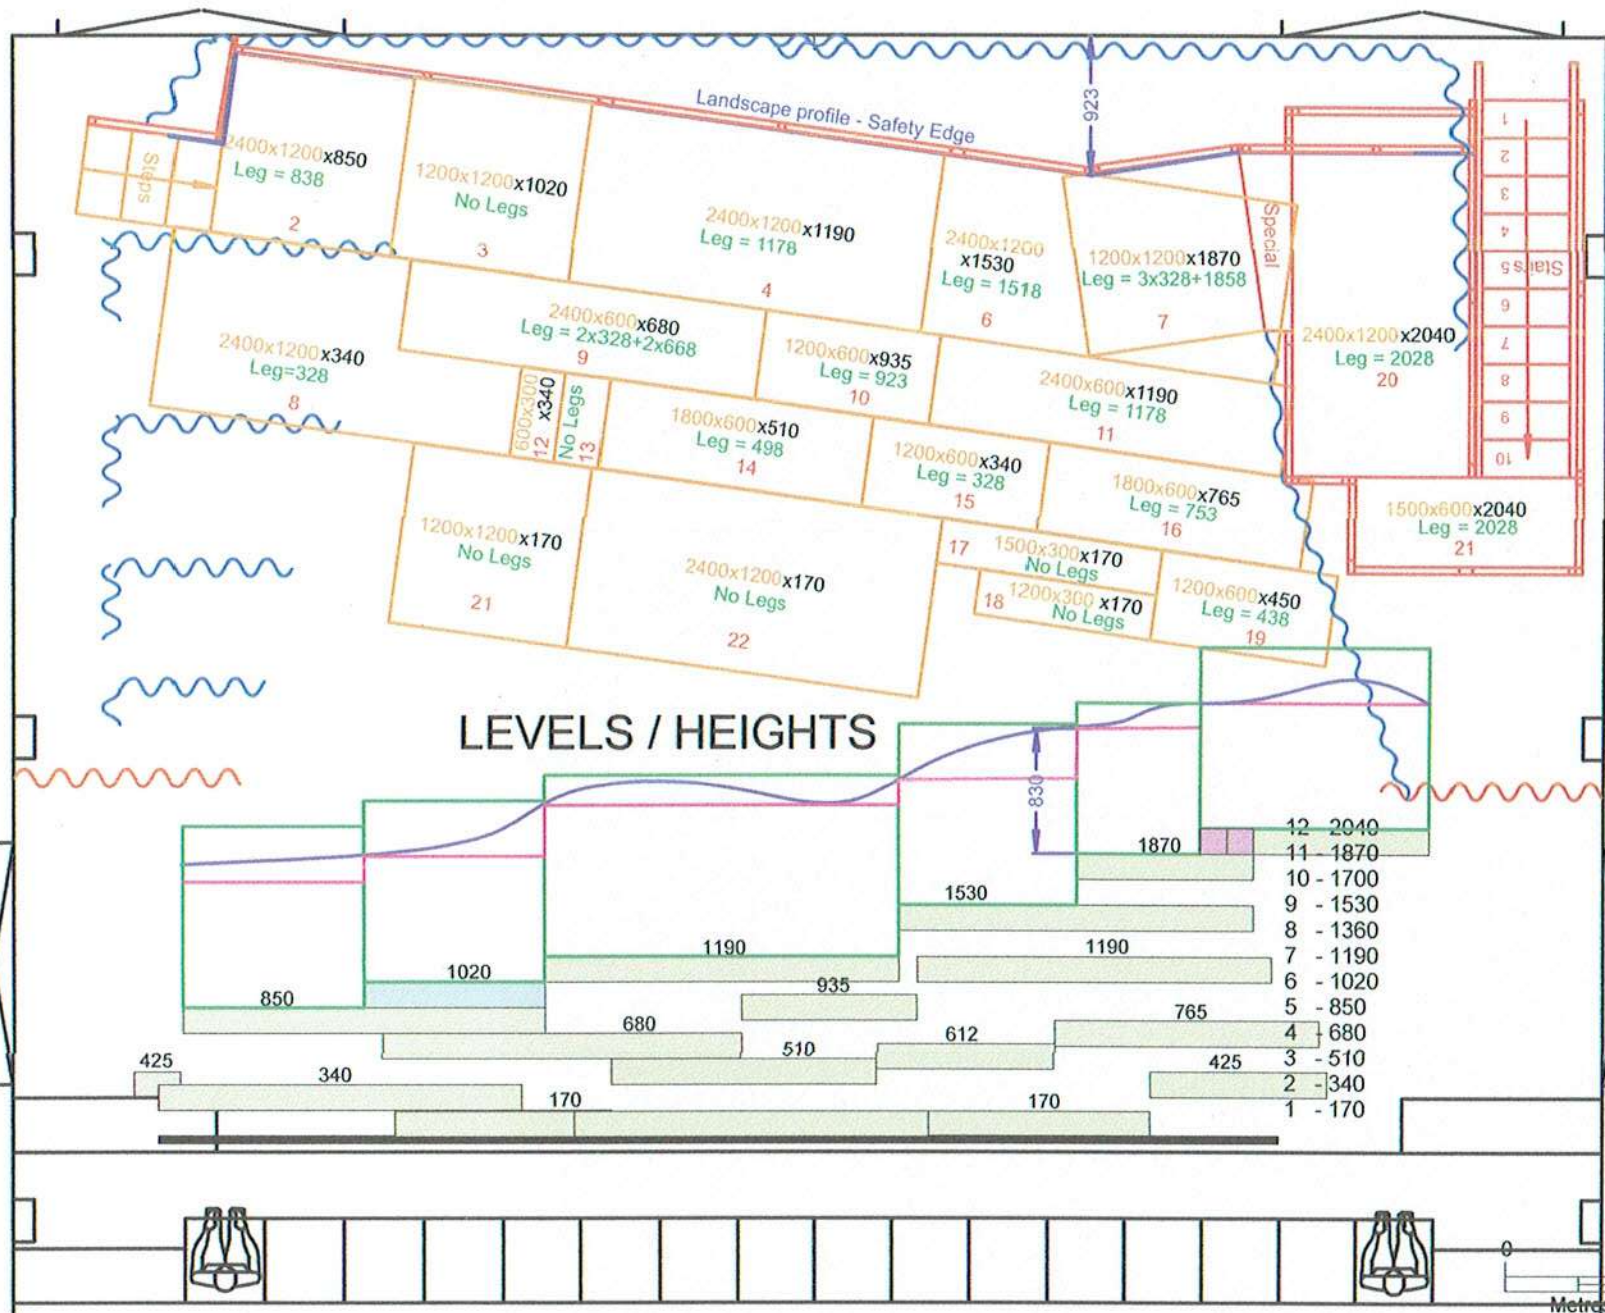

Event

Once On Chunuk Bair

Drawing

Set Layout

Producer

Company Theatre

Performance

09-23 May 2026

Date

29/04/26

Director

Paul Roukchan

Lighting Design

Stephen Hood

Drawn by


Scott Thomas

Venue

The Rose Centre


Rev

5

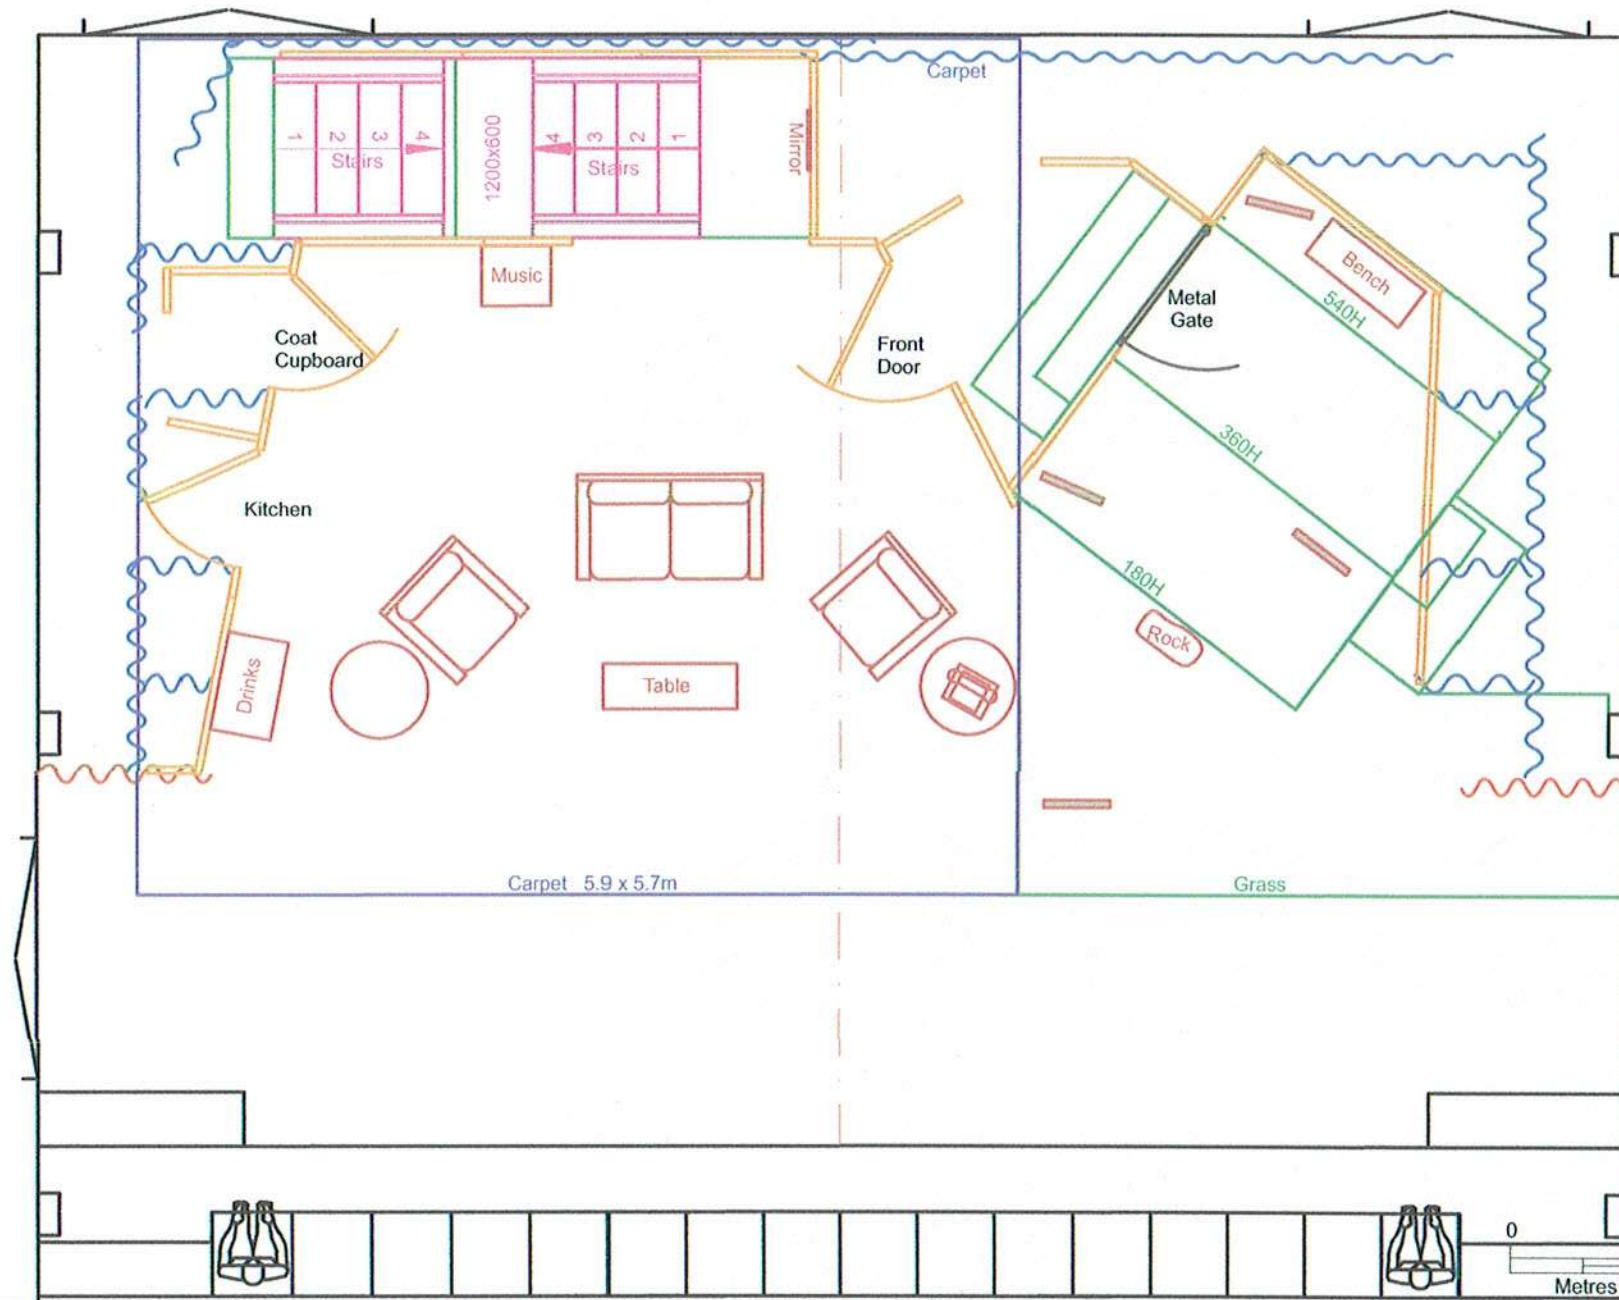

As Built

Event	Drawing	Producer	Performance	Date
The Cemetery Club	Set Layout	Company Theatre	08-22 Nov 2025	24/09/25
	Director	Lighting Design	Venue	Rev
	Kathy Gent	Stephen Hood	The Rose Centre	5

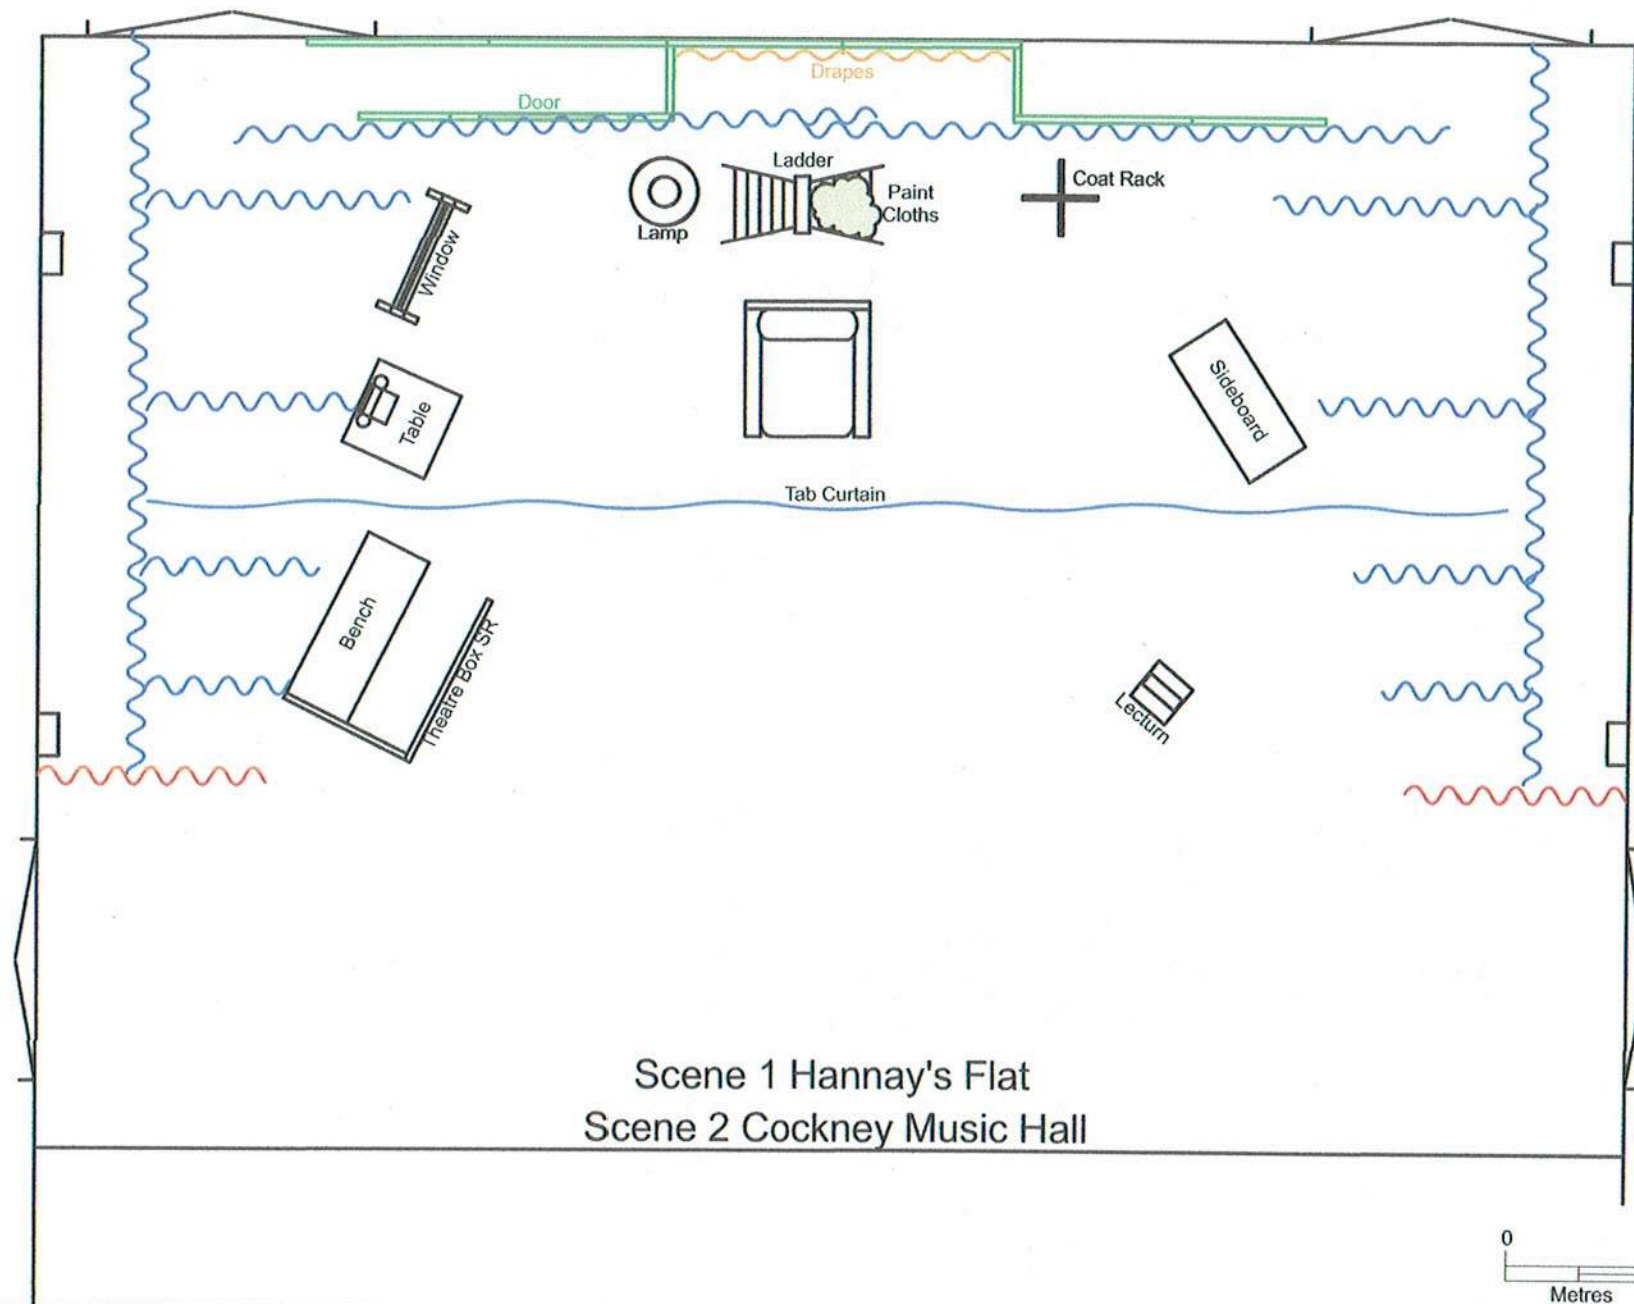

Event

The 39 Steps

Drawing

Set - Scene Layouts

Producer

Company Theatre

Performance

02-16 Aug 2025

Date

09/07/25

Director

Anthony Whitehouse

Lighting Design

Stephen Hood

Drawn by

Scott Thomas

Venue


The Rose Centre

Rev

4

GRID HEIGHT = 4.8m to bottom of cable trunking

Rose Luminaires
 12 12 Rama Fresnels
 6 6 PLFresnel1
 4 5 PLCyc1
 0 3 Cyc 500
 0 3 Flood 500
 0 2 Patt 123
 6 12 Mini fresnels
 0 3 Fresnels SF1000
 4 5 Compact Fresnels
 0 4 Par 64
 3 3 PC1000
 0 2 Profile 650
 5 5 Pacific 23-50

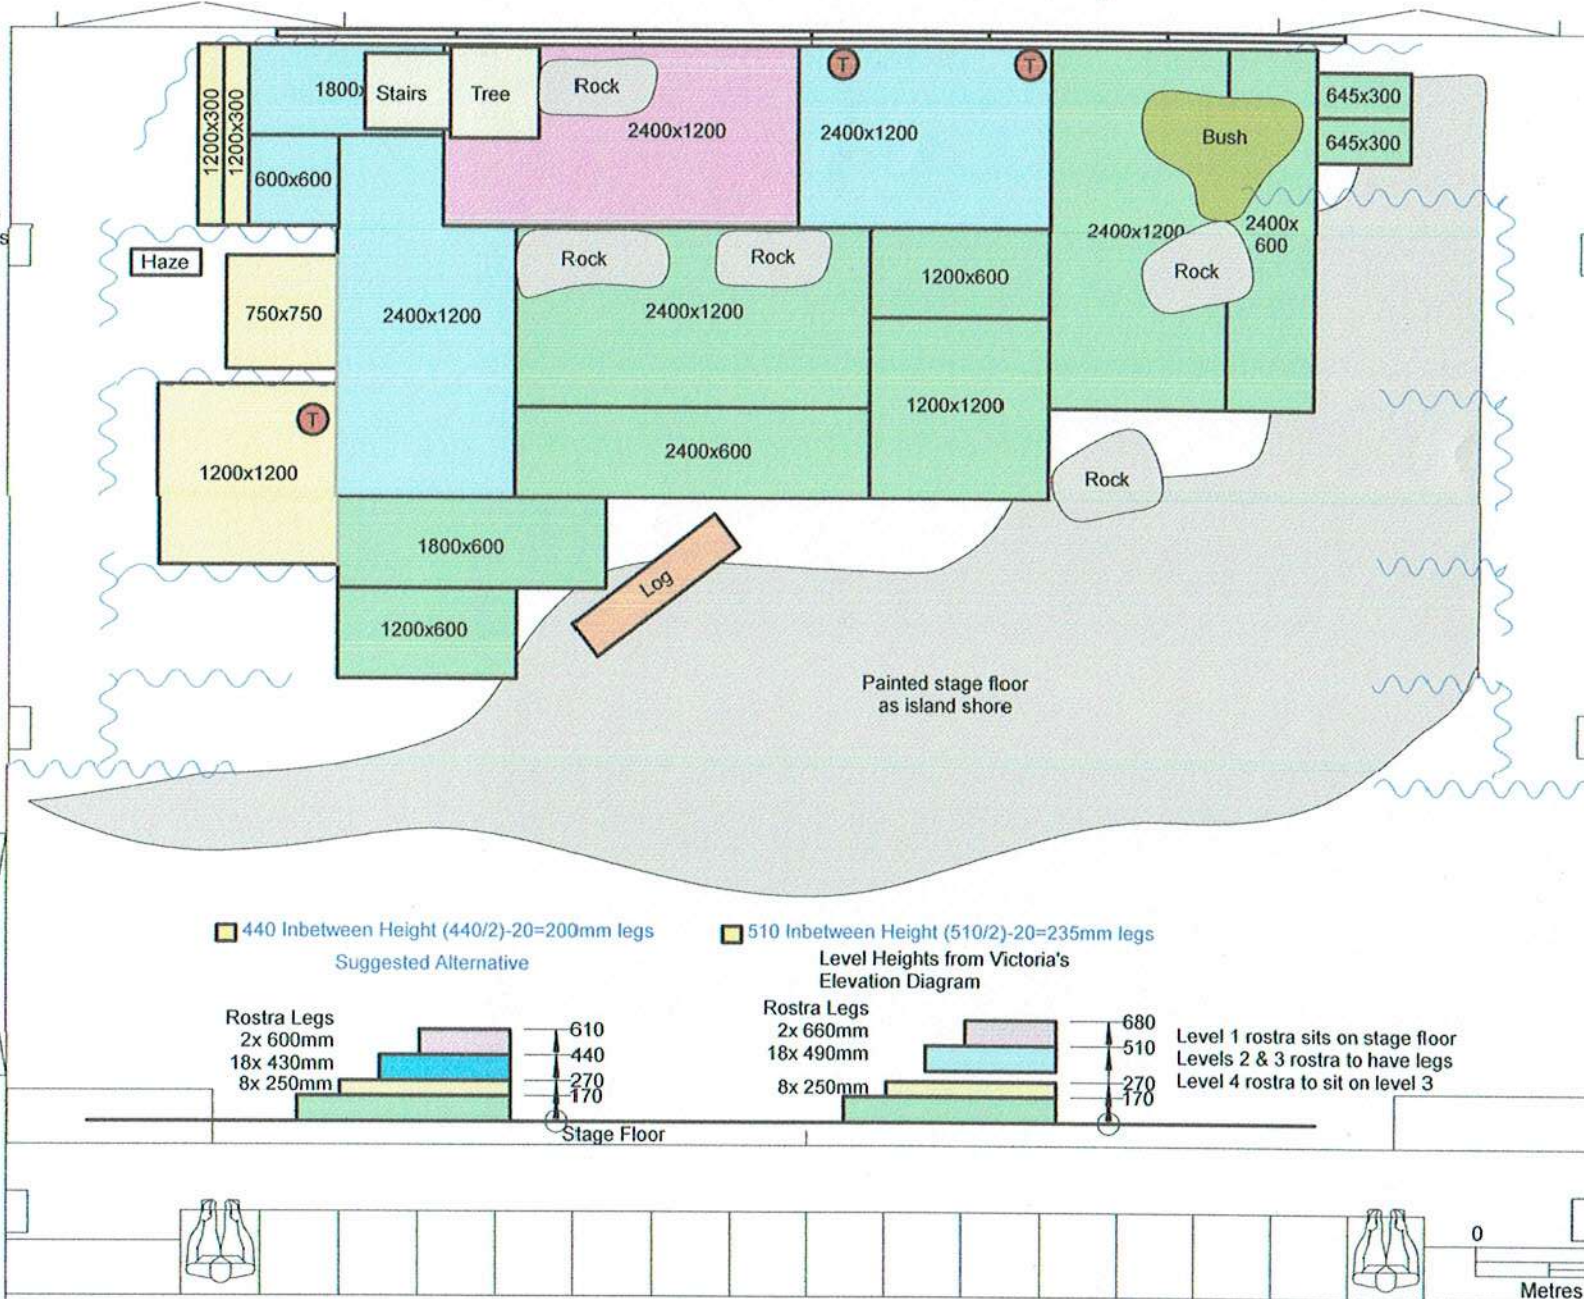

Rostra 170H
 5 7x 2400x1200 New
 2 2x 1200x1200 New
 2 2x 2400x600 New
 2 2x 1800x600
 2 2x 1200x600
 0 2x 1500x300
 0 1x 1200x300
 2 2x 645x300
 1 1x 750x750

Steps
 1x 3Stepx900x610H
 2x 3Stepx800x610H

Staircase
 2x 4 Step
 2x 6 Step

Flats 3000H
 6 7x 1200
 3 3x 1200 (2 halves ea)
 3x 900
 8x 600
 5x 300
 1x 600x1500
 1x 600x1200
 1x 600x600

Door Flat 2400H ??
 2x 1200

Event

Sheila's Island

Drawing

Director
 Kathy Gent

Producer

Company Theatre

Lighting Design

Scott Thomas

Drawn by

Scott Thomas

Performance

16-30 Nov 2024

Venue


The Rose Centre

Date

20/10/24

Rev

3

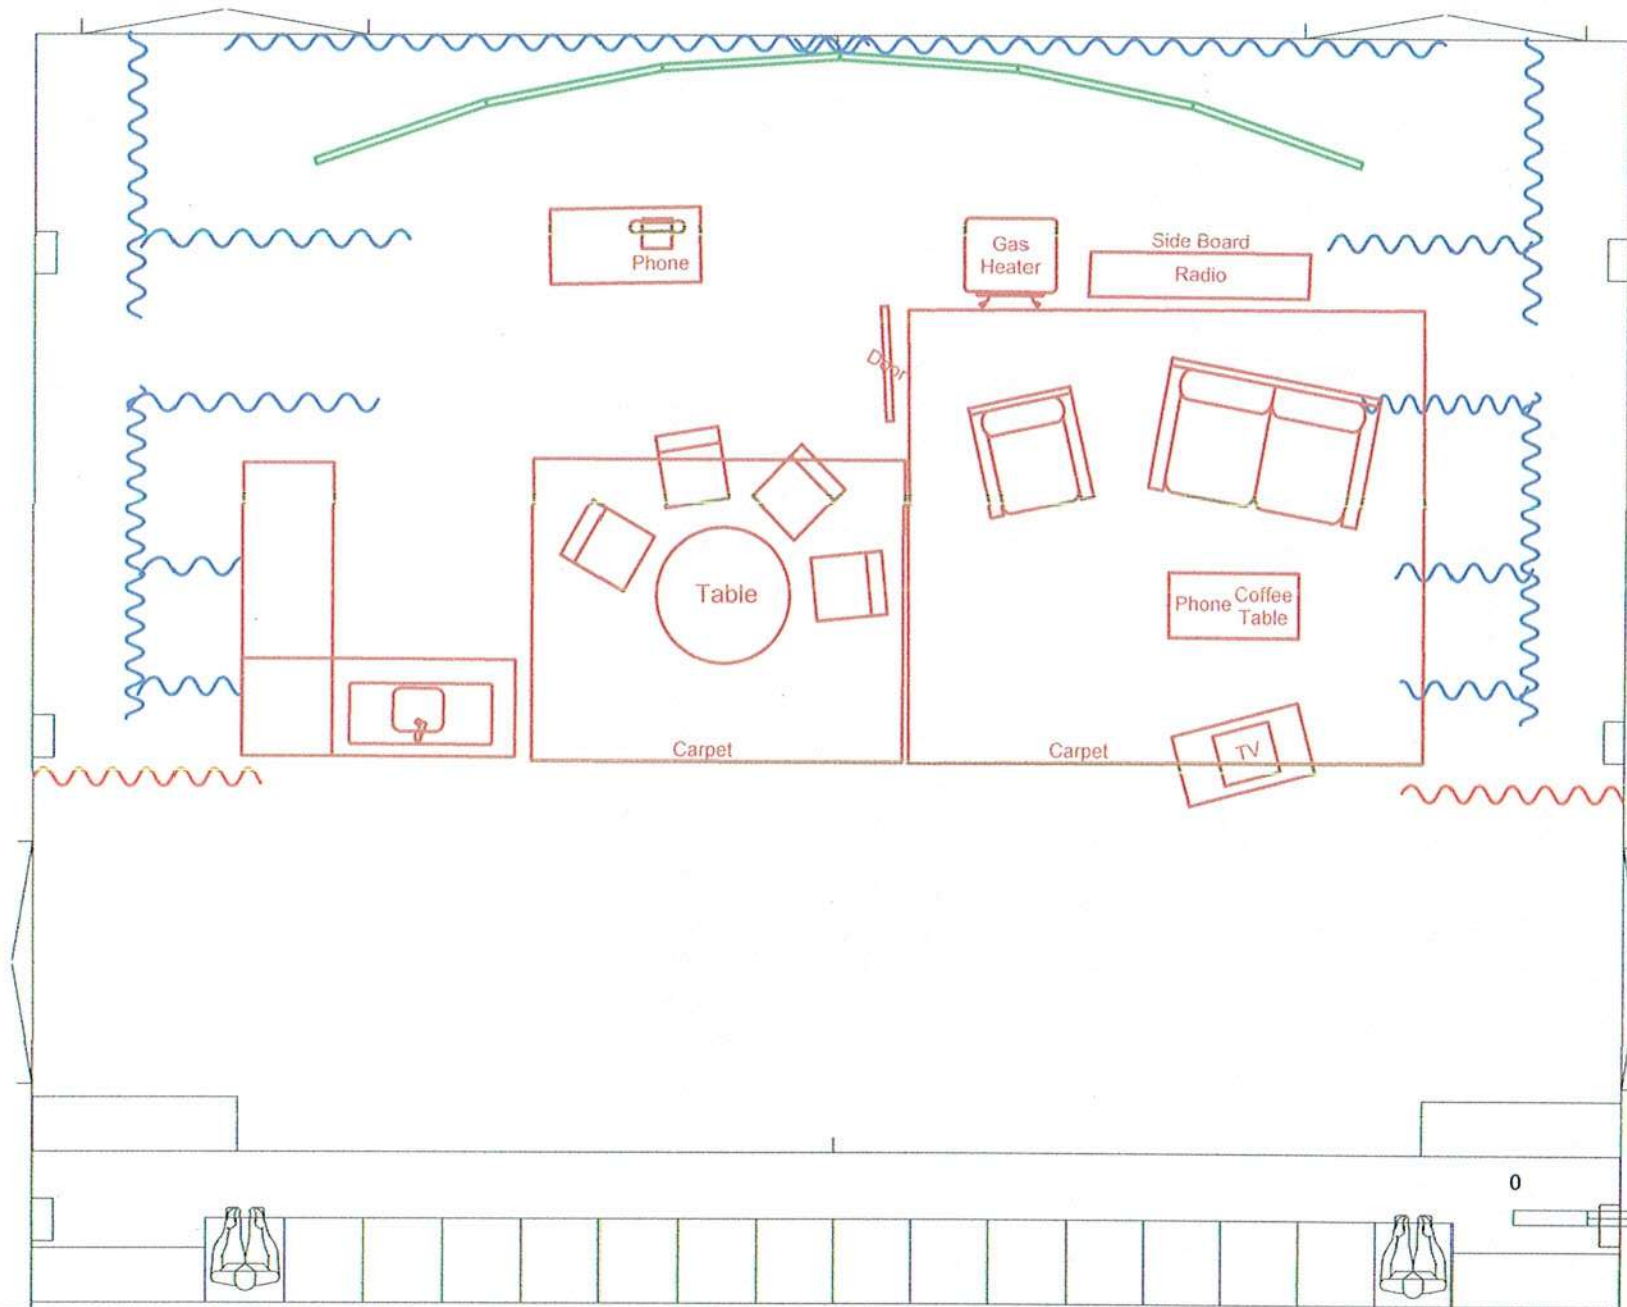

Event

Home Land

Drawing

Set - Plan View - Option

Producer

Company Theatre

Performance

17-31 Aug 2024

Date

15/07/24

Director

Siân Davis

Lighting Design

Scott Thomas

Drawn by

Scott Thomas

Venue


The Rose Centre

Rev

1.2

GRID HEIGHT = 4.8m to bottom of cable trunking

PROJECTION: 4:3 = 5.3W x 4H

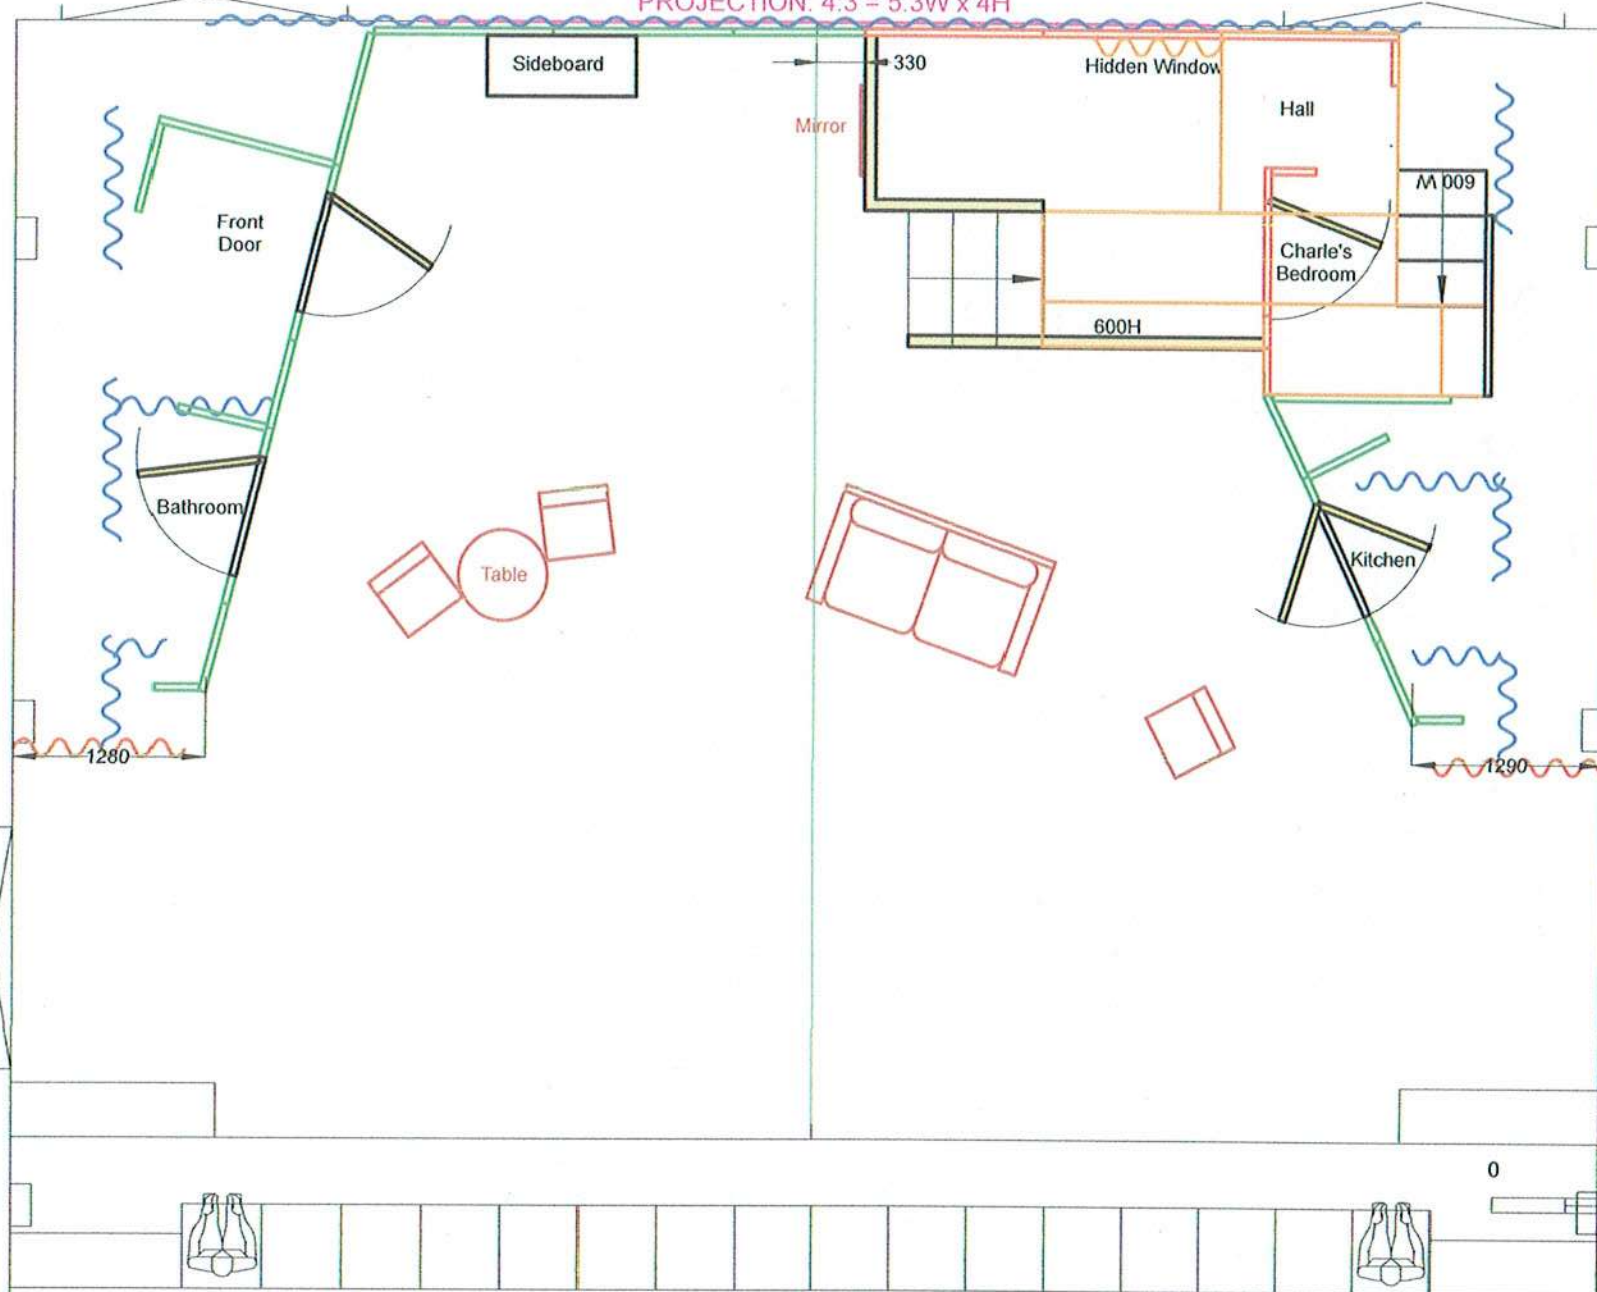


- Rostra 170H**
- 1 7x 2400x1200 New
 - 1 2x 1200x1200 New
 - 1 2x 2400x600 New
 - 0 2x 1800x600
 - 1 2x 1200x600
 - 1 2x 1500x300
 - 0 1x 1200x300
 - 1 2x 645x300
 - 0 1x 750x750
- Steps**
- 0 1x 3Stepx900x610H
 - 0 2x 3Stepx800x610H
- Staircase**
- 0 2x 4 Step
 - 0 2x 6 Step
- Flats 3000H**
- 7 10x 1200
 - 2 3x 900
 - 7 8x 600
 - 5 5x 300
 - 4 3x 1200 Door

Event	Drawing				Producer		Performance		Date
	<i>Rumours</i>				Company Theatre		11-25 Nov 2023		24/09/23
	Director		Lighting Design		Drawn by		Venue		Rev
	Kate Birch				Scott Thomas		The Rose Centre		2

GRID HEIGHT = 4.8m to bottom of cable trunking

PROJECTION: 4:3 = 5.3W x 4H

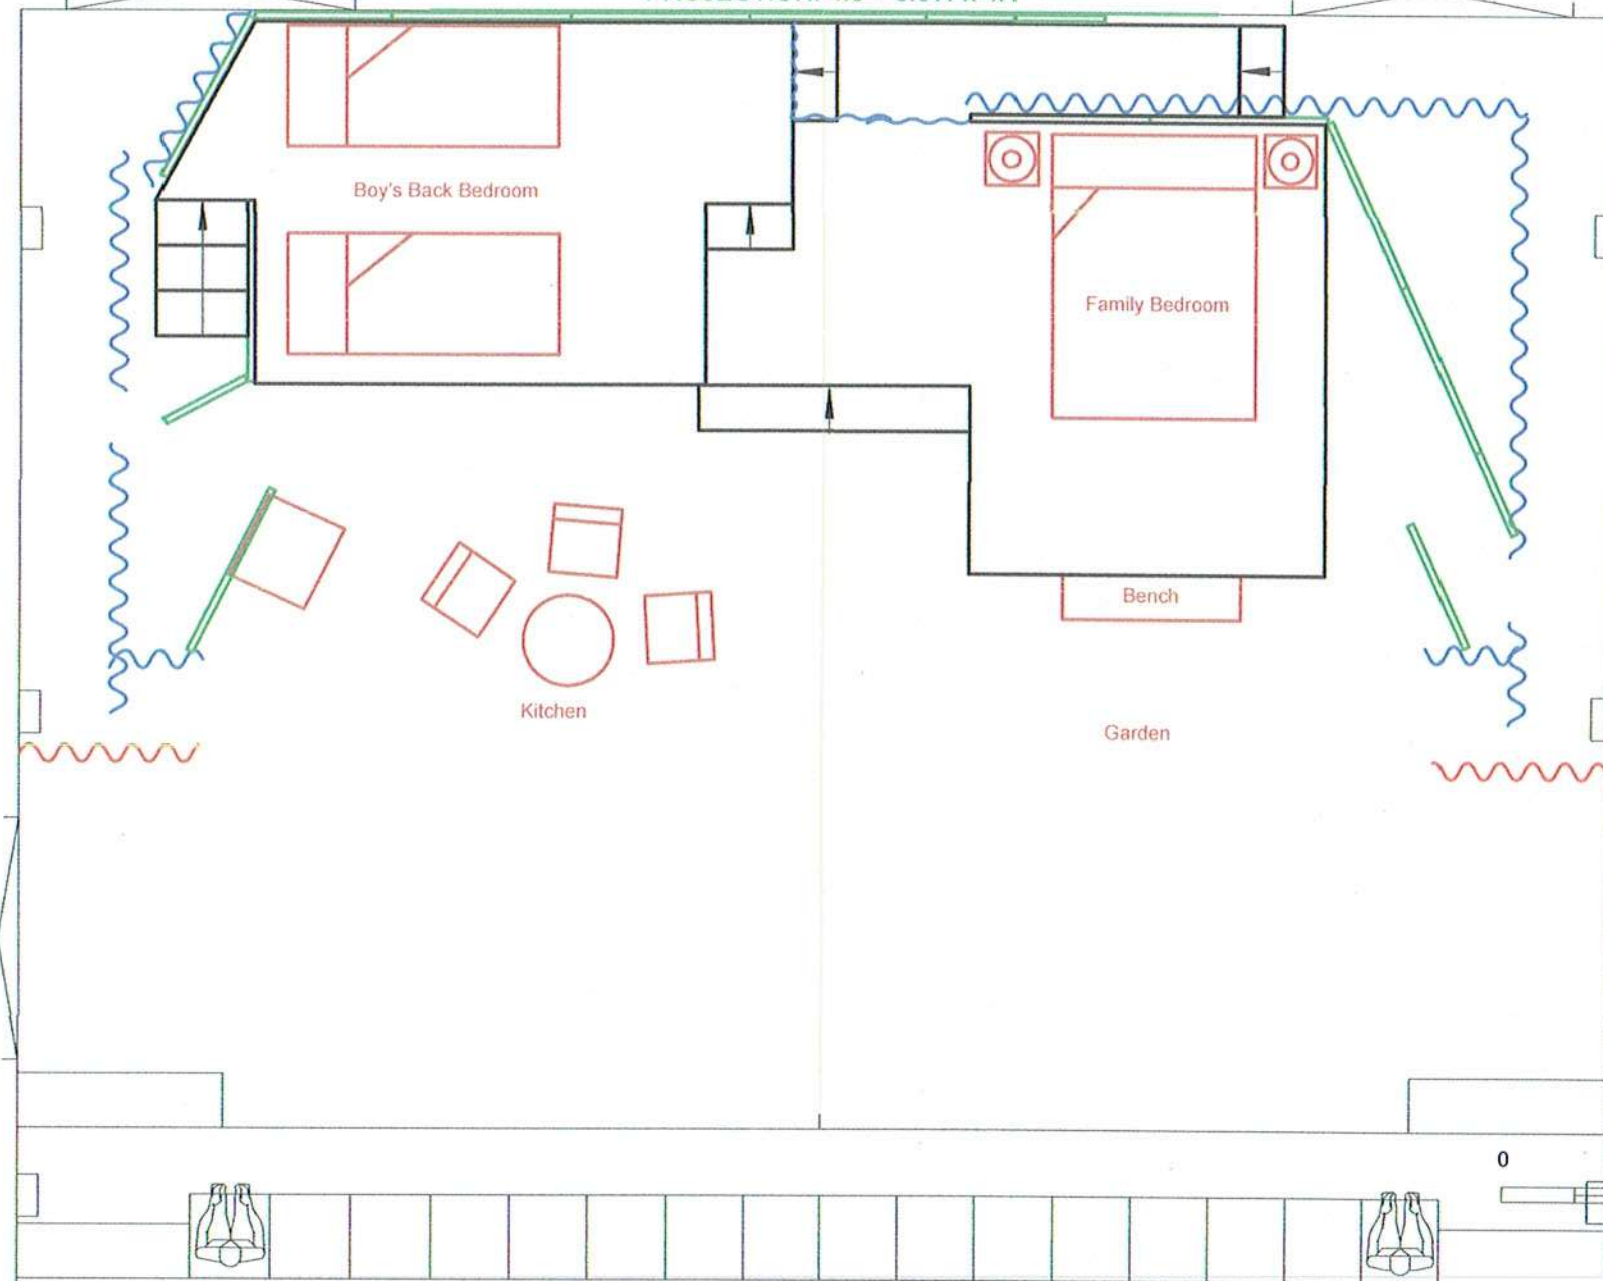

Rostra 170H
 7x 2400x1200 New
 2x 1200x1200 New
 2x 2400x600 New
 2x 1800x600
 2x 1200x600
 2x 1500x300
 1x 1200x300
 2x 645x300
 1x 750x750


Steps
 1x 3Stepx900x610H
 2x 3Stepx800x610H

Staircase
 2x 4 Step
 2x 6 Step

Flats 3000H
 8x 1200
 3x 900
 3x 600
 5x 300
 2x 1200 Door

Event Death of a Salesman	Drawing Set Layout - Act 1 Director Siân Davies	Producer Company Theatre Lighting Design Scott Thomas Drawn by Scott Thomas	Performance 11-26 Aug 2023 Venue The Rose Centre	Date 19/07/23 Rev 3.2
-------------------------------------	--	--	---	--------------------------------

GRID HEIGHT = 4.8m to bottom of cable trunking
PROJECTION: 4:3 = 5.3W x 4H

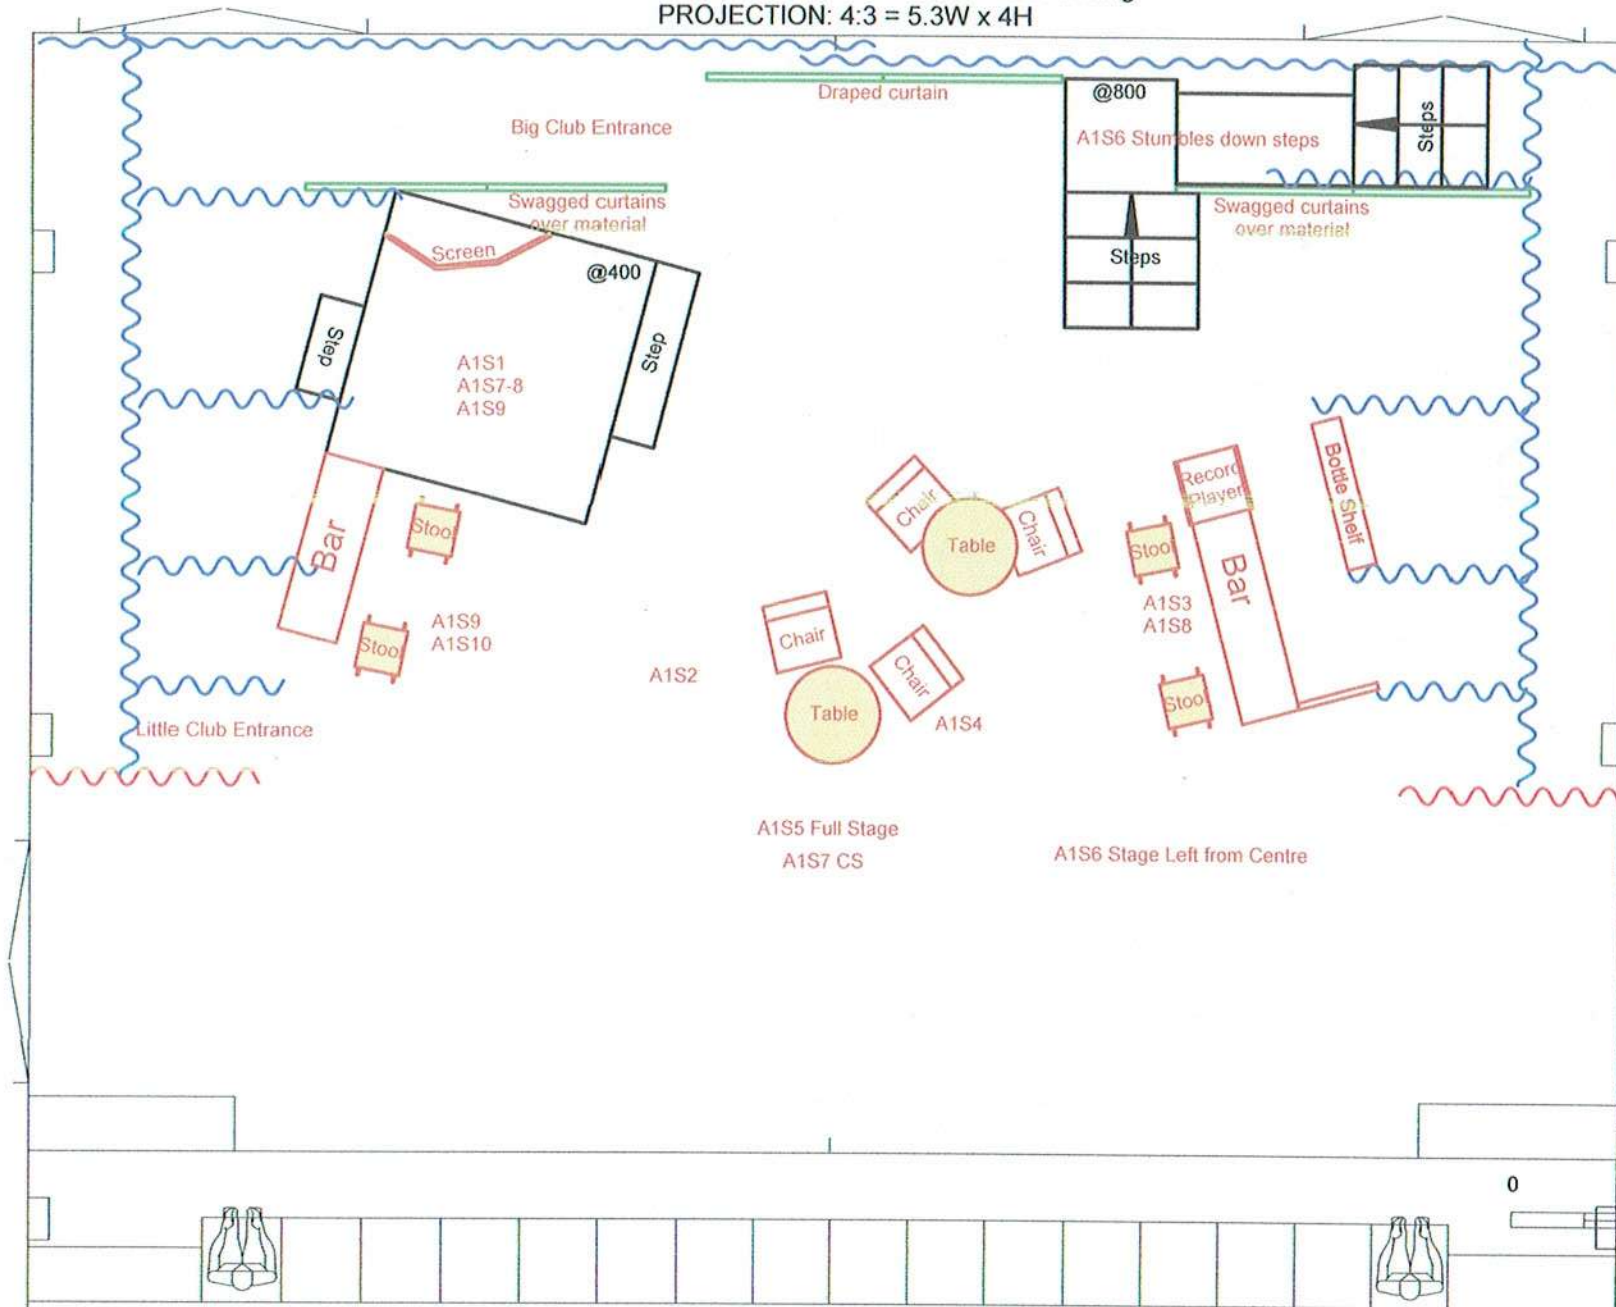

Event

The Thrill of Love

Drawing

Act 1 Set Layout

Director

Kathy Gent

Lighting Design

Sam Mence

Producer

Company Theatre

Drawn by

Scott Thomas

Performance

13-27 Aug 2022

Venue

The Rose Centre

Date


10/07/22

Rev

3

GRID HEIGHT = 4.8m to bottom of cable trunking

PROJECTION: 4:3 = 5.3W x 4H

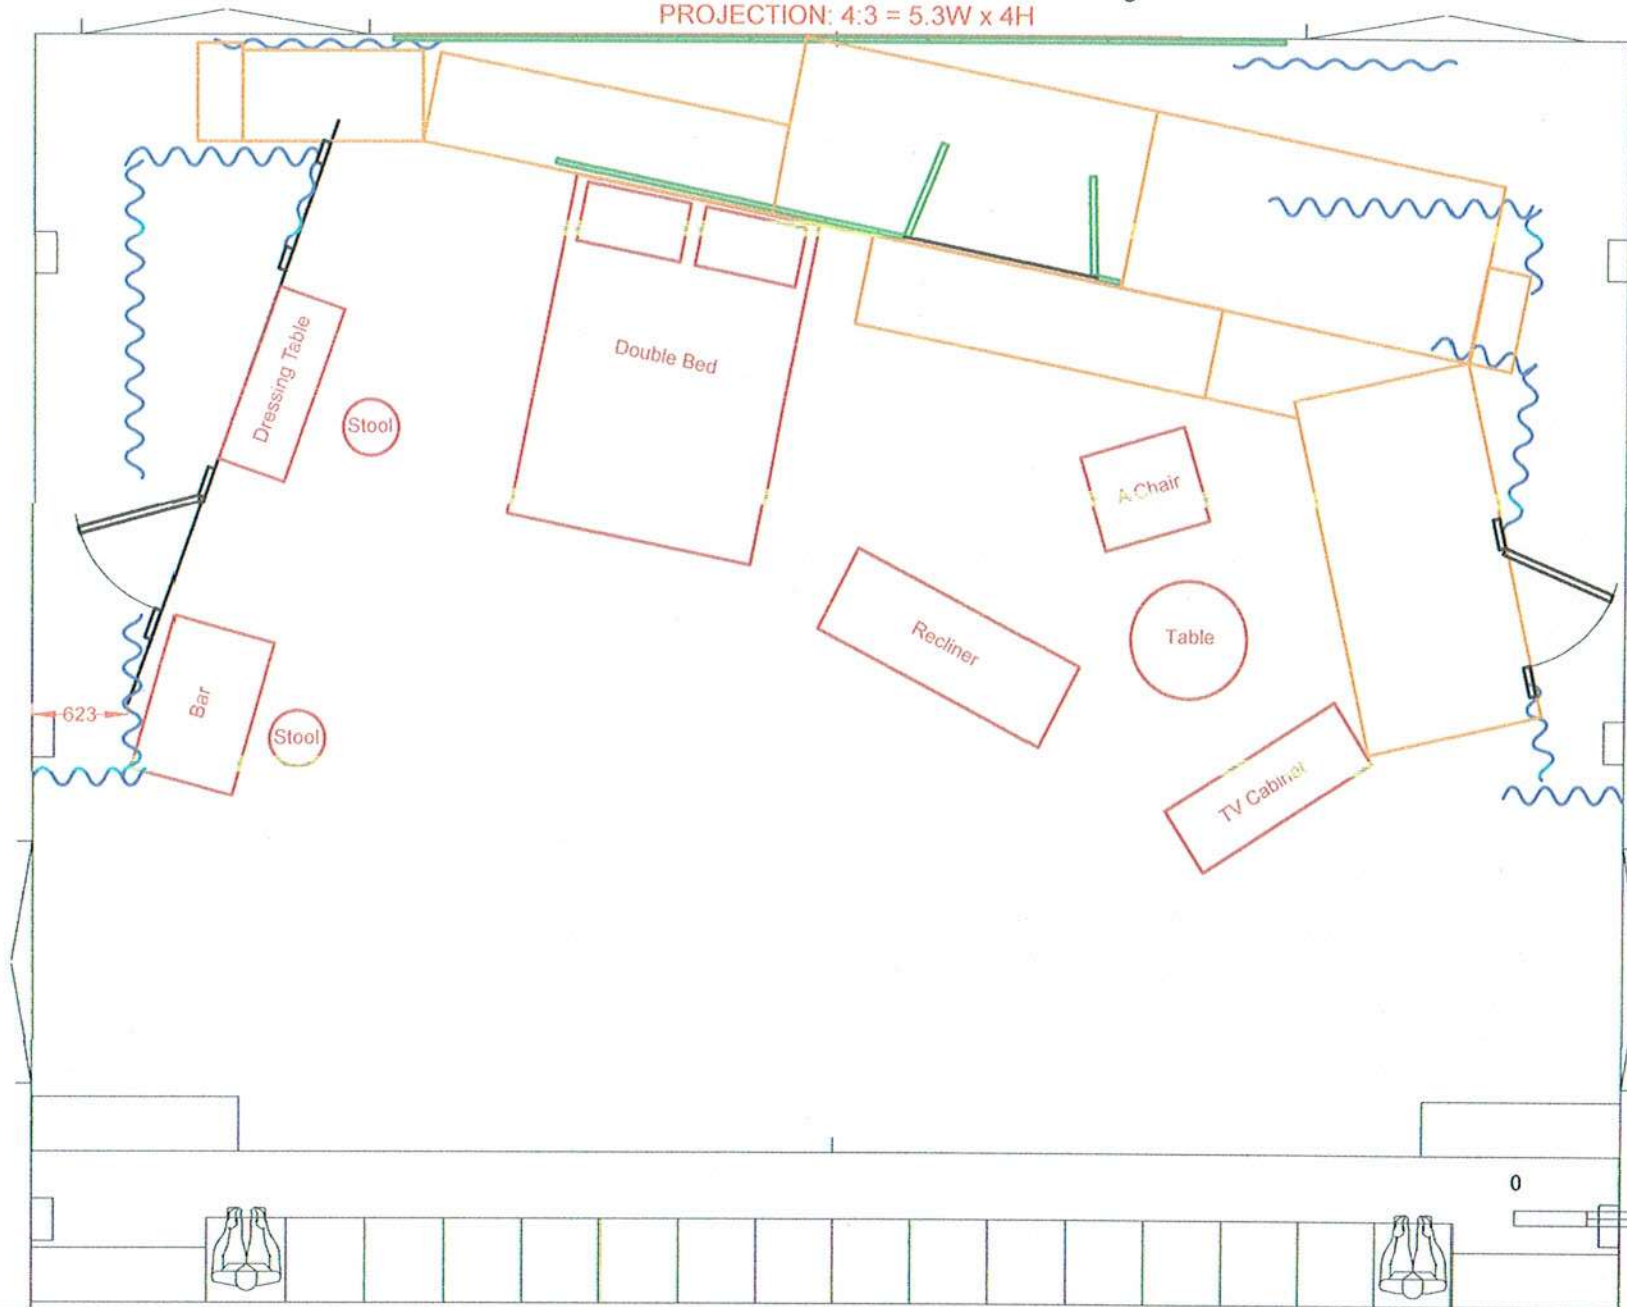

Event

**Cat on a
Hot Tin Roof**

Drawing

Lighting Layout

Producer

Company Theatre

Performance

15-29 May 2021

Date

11/04/21

Director

Siân Davis

Lighting Design

Scott Thomas

Drawn by


Scott Thomas

Venue

The Rose Centre

Rev

1

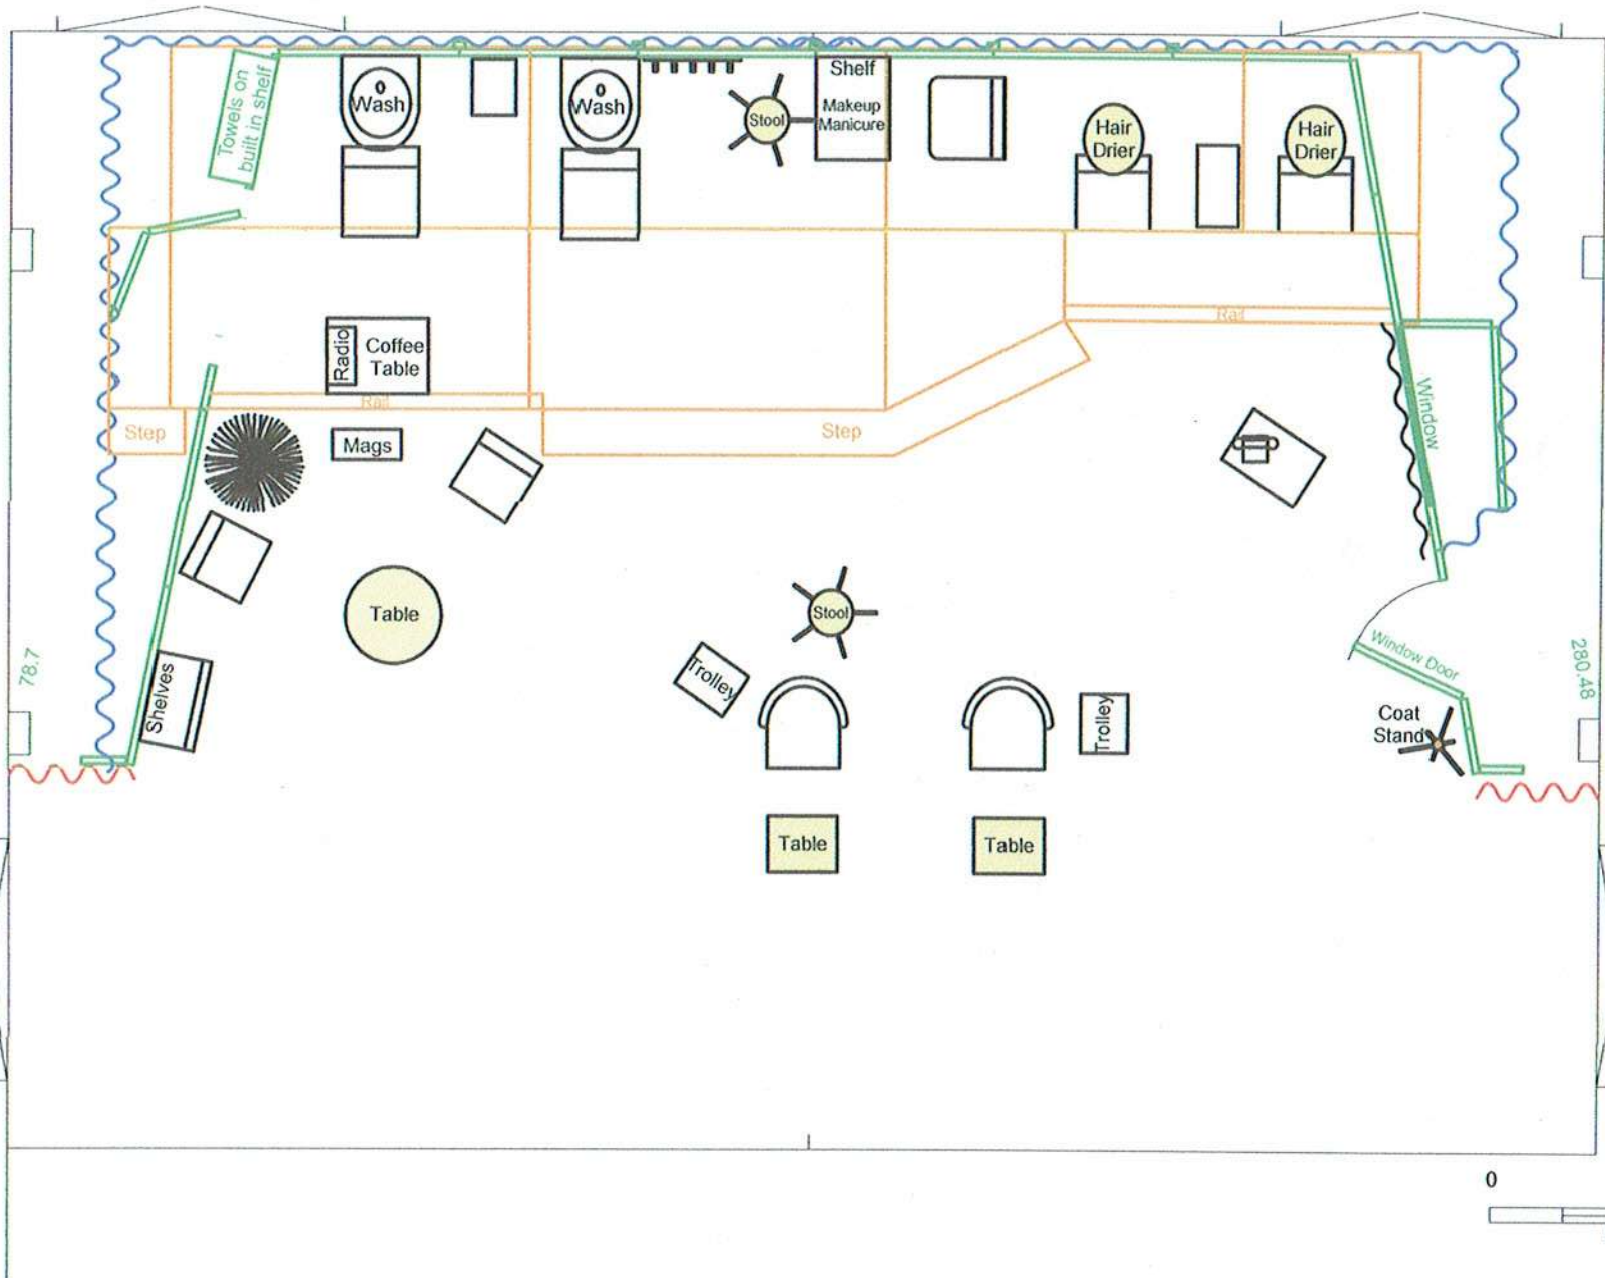

Event

Steel Magnolias

Drawing

Director
Kathy Gent

Producer

Company Theatre

Lighting Design
Scott Thomas

Drawn by
Scott Thomas

Performance

17-31 Aug 2019

Venue


The Rose Centre

Date

01/08/19

Rev

5

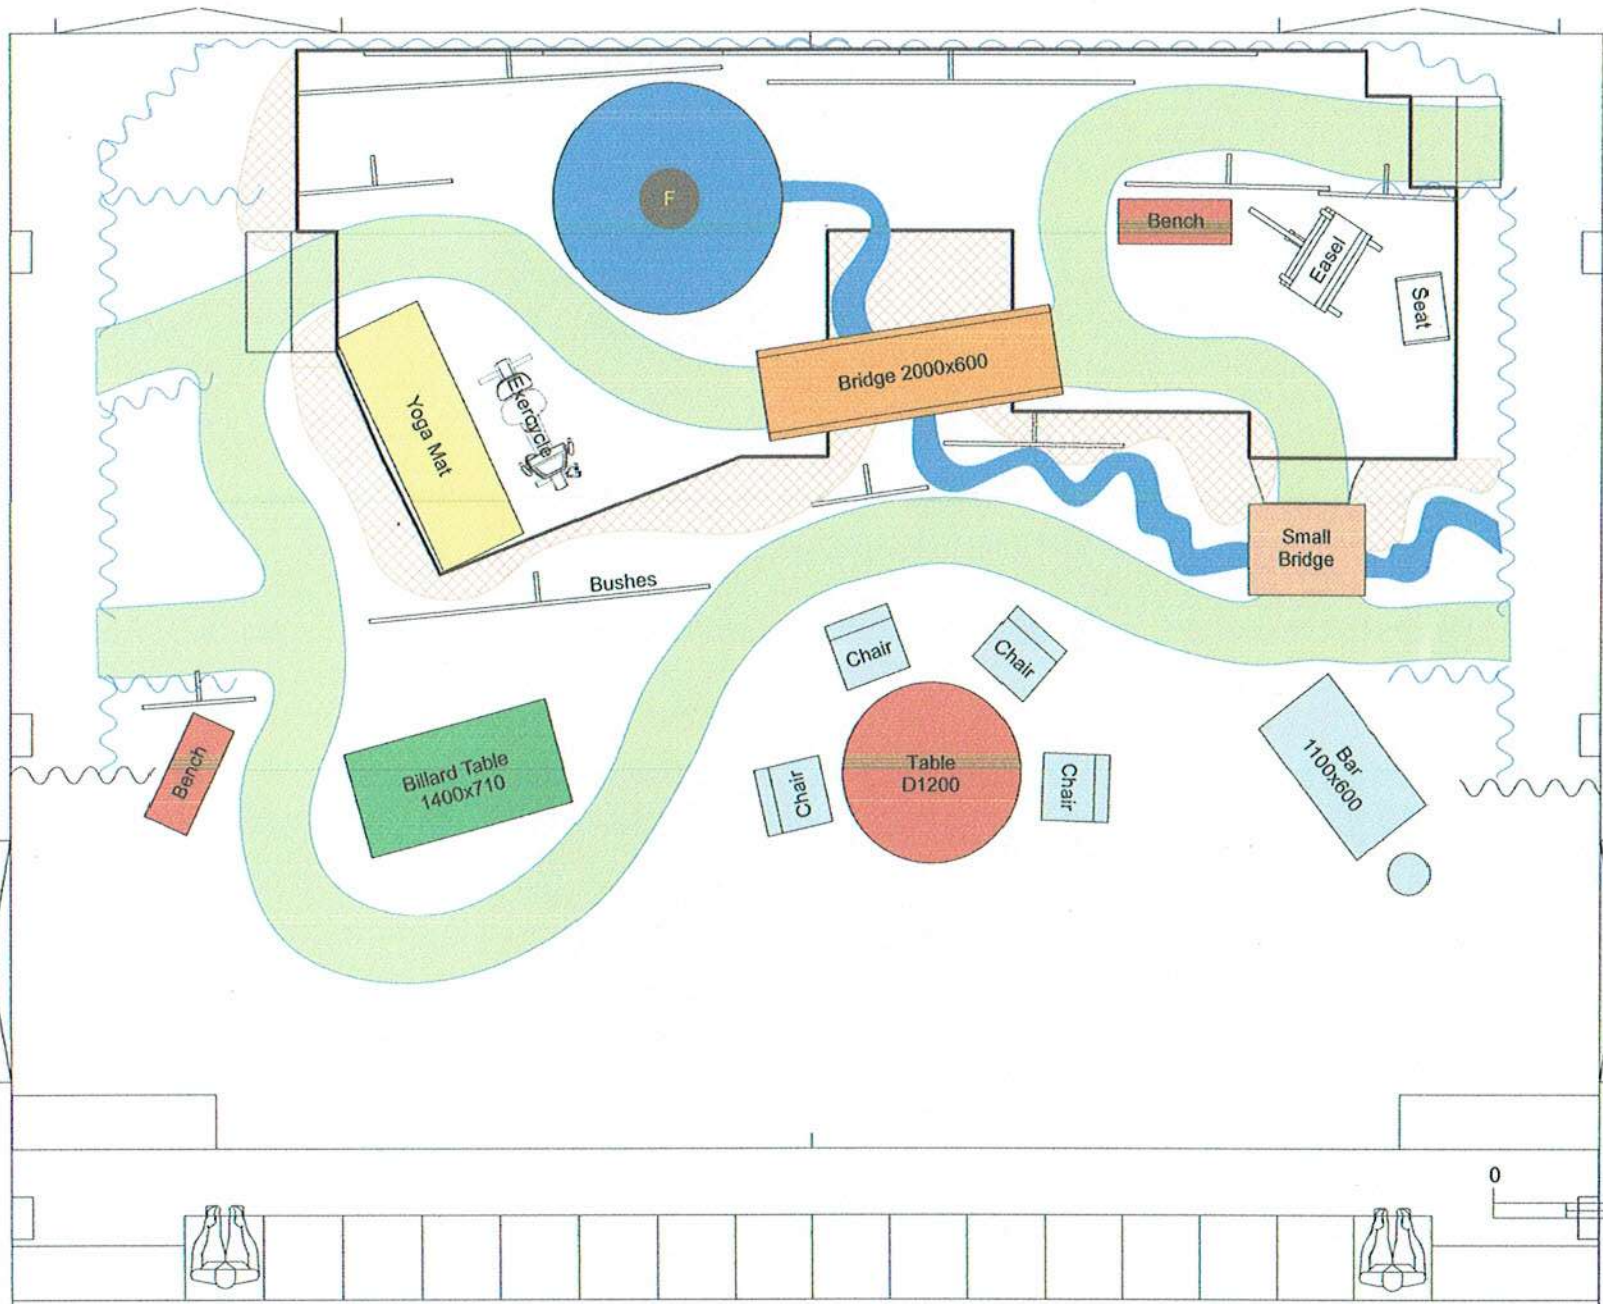

Event

LAST LEGS

Drawing

Set Plan View

Director

Siân Davis

Producer

Company Theatre

Drawn by

Scott Thomas

Performance

17-1 Dec 2018

Venue


The Rose Centre

Date


25/08/18

Rev

8

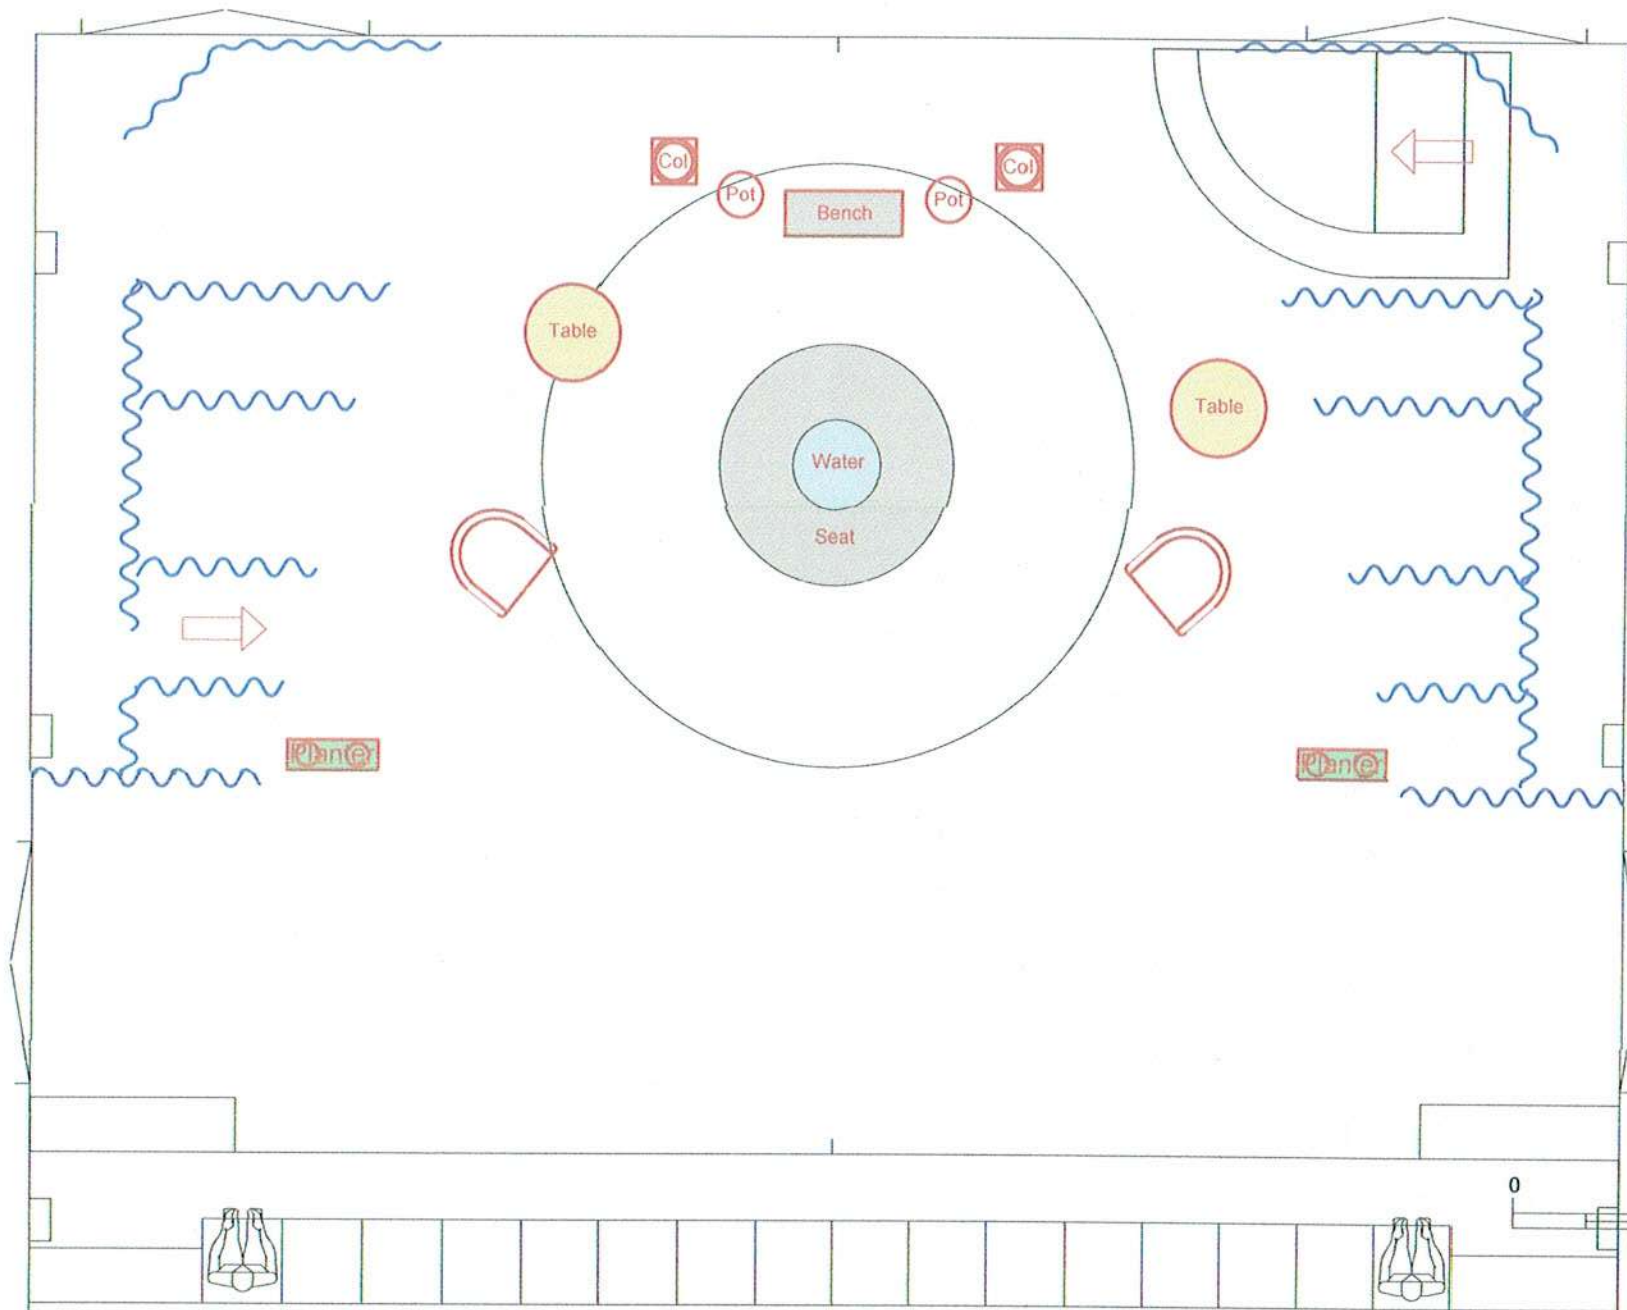

Event	<i>The Importance of Being Earnest</i>				Drawing Act 3 - Drawing Room at Woolton		Producer Company Theatre		Performance 11-25 Aug 2017	Date 26/06/18
					Director Anne Rimmer	Lighting Design Scott Thomas	Drawn by Scott Thomas	Venue The Rose Centre	Rev 0.4	

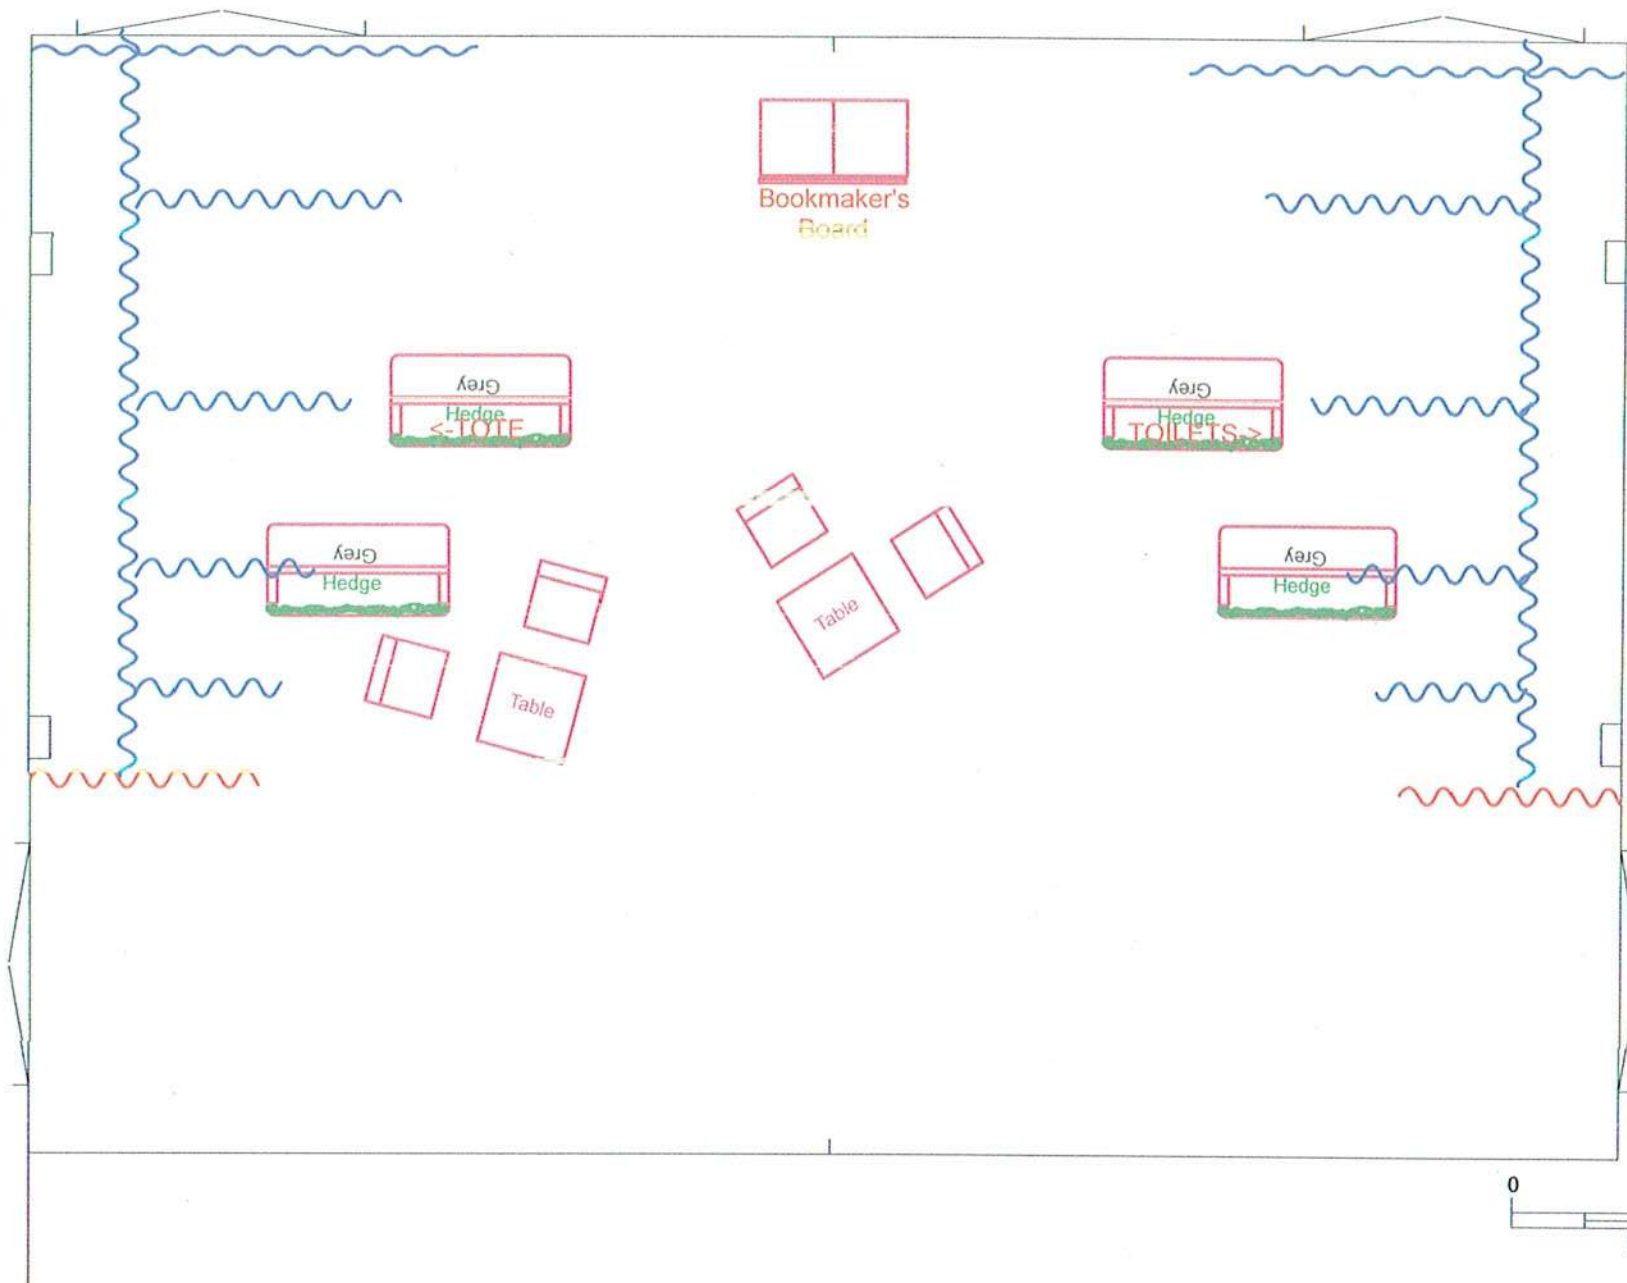

Event

Ladies Day

Drawing

A1 S4 Enclosure

Producer

Company Theatre

Performance

12-26 Aug 2017

Date

17/07/17

Director

Kathy Gent

Set Construction

Ian Birch

Lighting Design

 

Scott Thomas

Venue

The Rose Centre

Rev

0.2

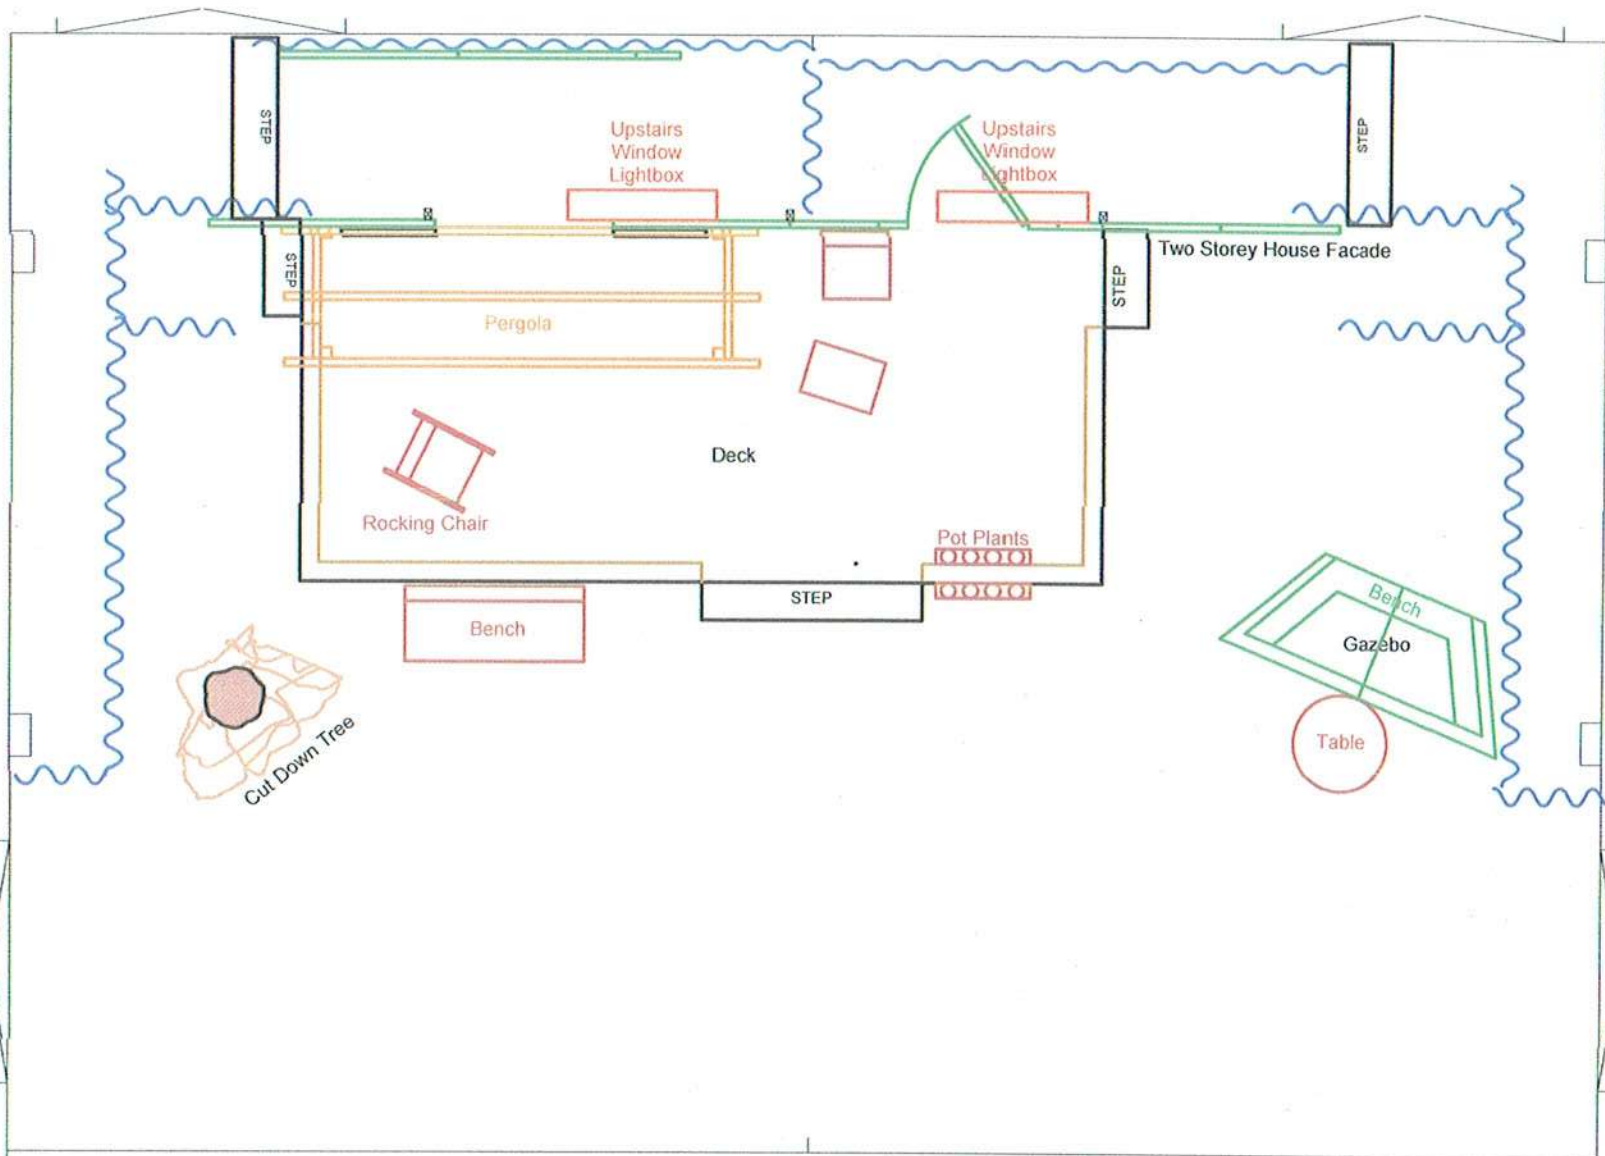

Event

All My Sons

Drawing

Floor Plan

Director

Siân Davis

Set Design

Siân Davis

Producer

Company Theatre

Lighting Design

Scott Thomas

Performance

6-20 Aug 2016

Venue


The Rose Centre

Date

23/06/16


Rev

1.8


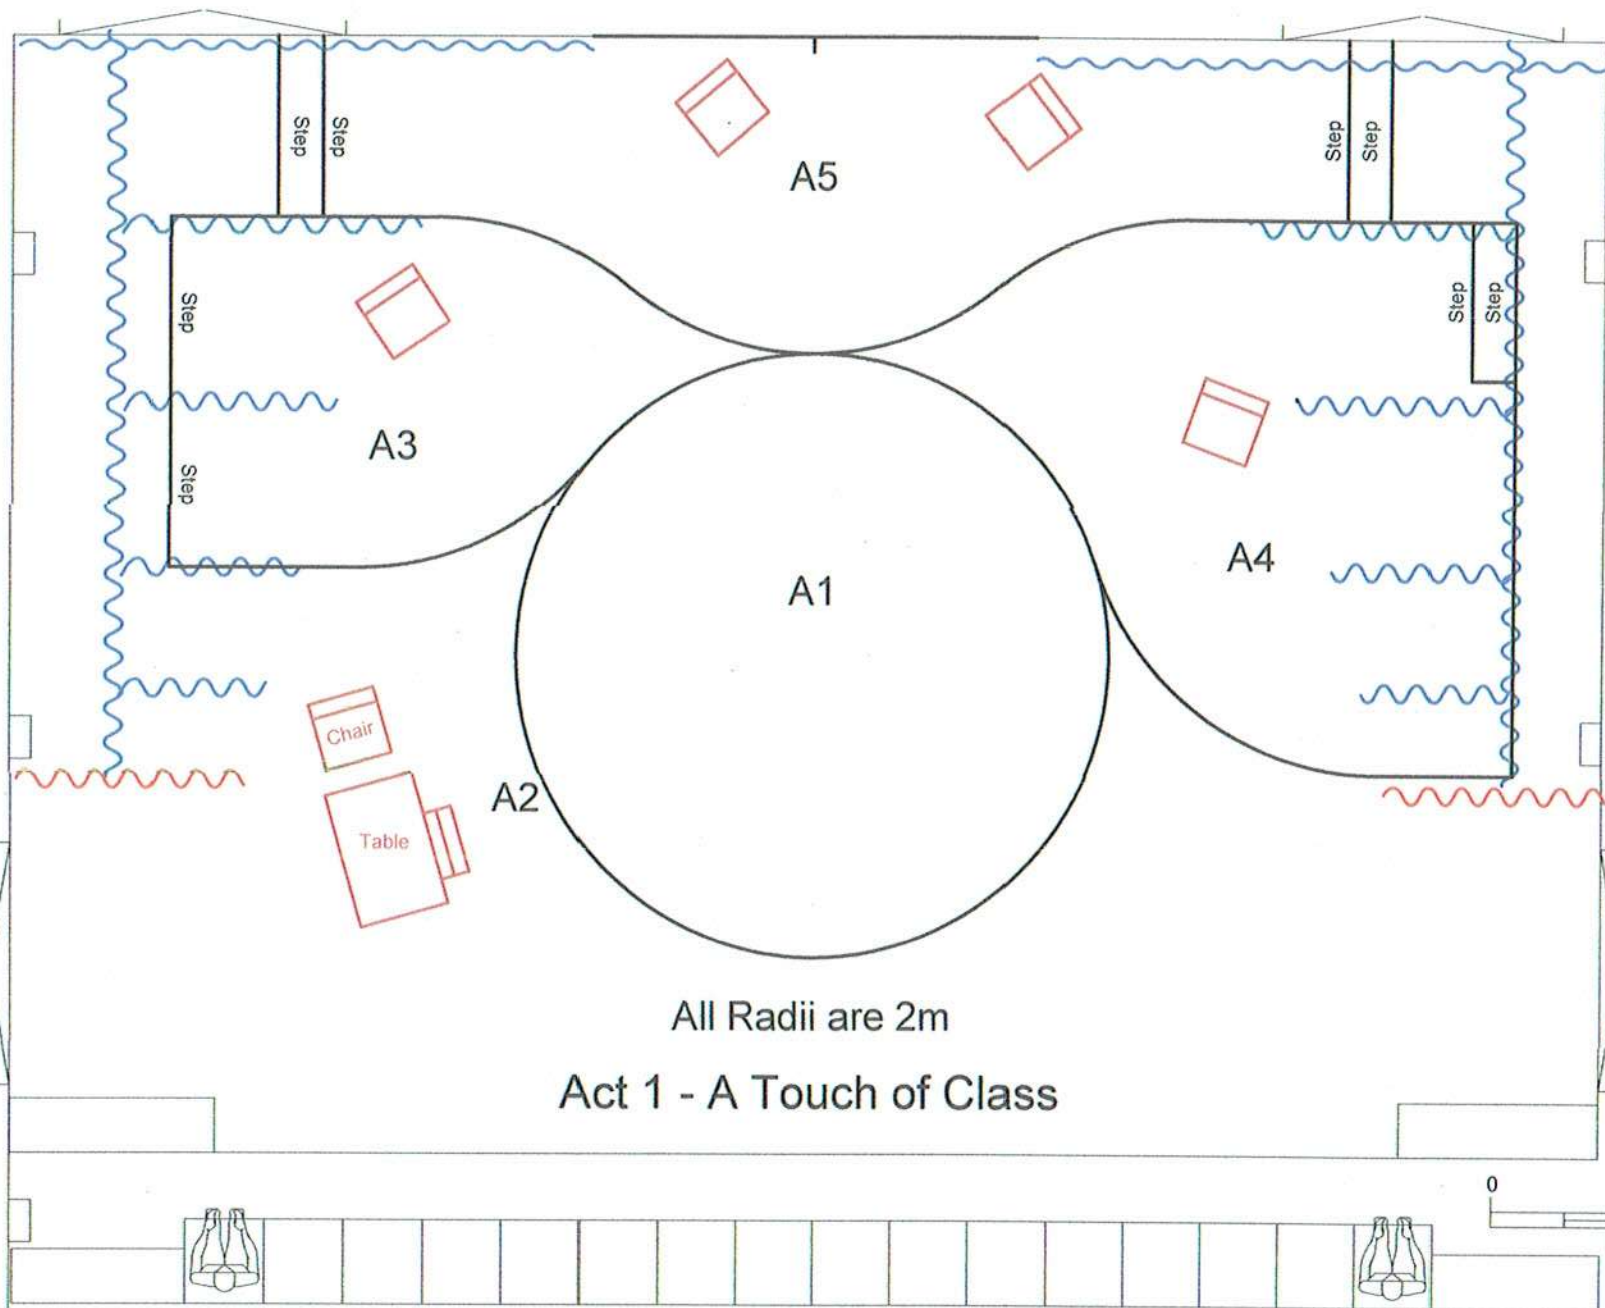


- A1S1 A1
- A1S2 A
- A1S3 A1
- A1S4 A4
- A1S5 A3
- A1S6 A2
- A1S7 A3
- A1S8 A1
- A1S9 A1,4,5
- Interval
- A2S1 A1
- A2S2 A5
- A2S3 A3
- A2S4 A4
- A2S5 A5
- A2S6 A2
- A2S7 A5
- A2S8 A5
- A2S9 A
- A2S10 A5

Event	Drawing				Producer		Performance	Date
	Floor Plan				Company Theatre		2-16 Apr 2016	14/01/16
		Director	Set Design		Lighting Design	Venue		Rev
When Dad Met Fury		Max Golding	Max Golding		Stephen Hood	The Rose Centre		0.3

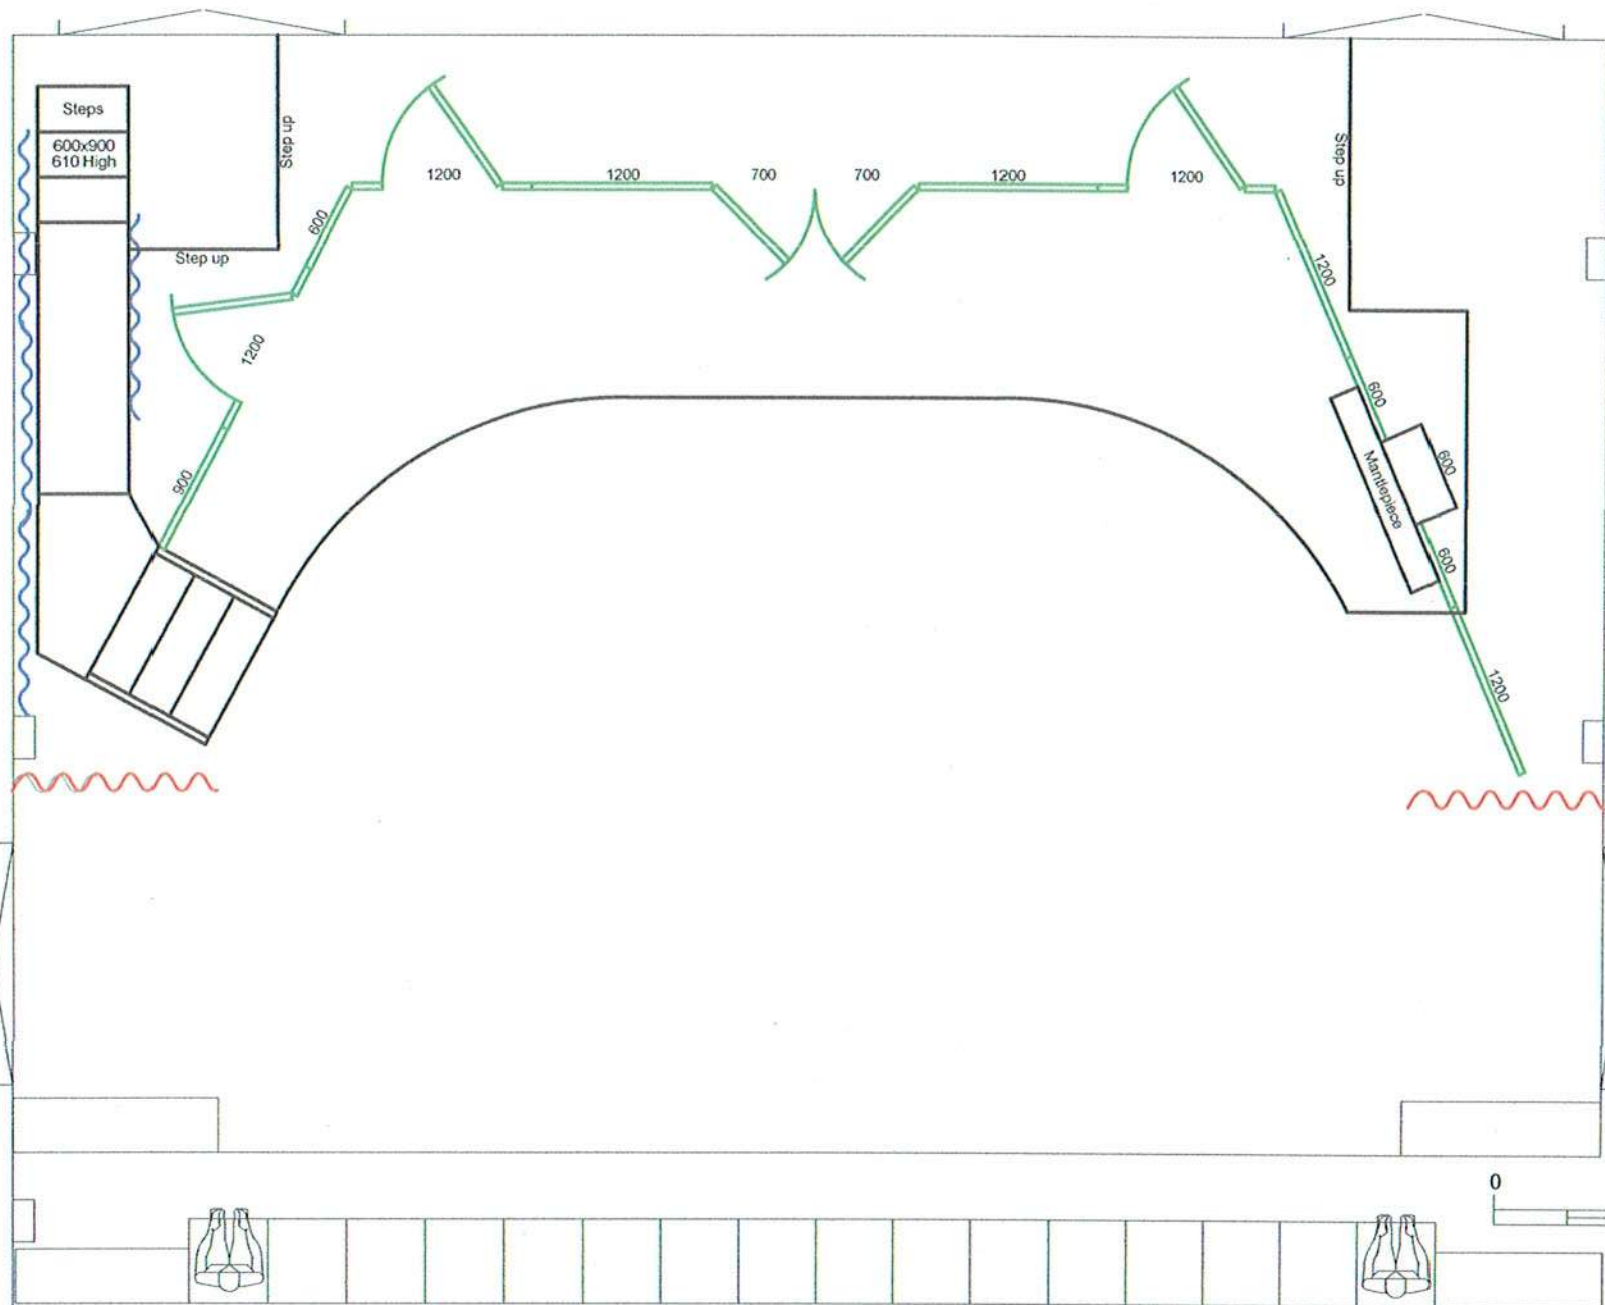

Event	Drawing		Producer		Performance	Date
	Don't Dress For Dinner		Company Theatre		14-28 Nov 2015	19/09/15
	Director	Set Design	Lighting Design		Venue	Rev
	Elena Stejko	Phil Davis	Stephen Hood		The Rose Centre	1

 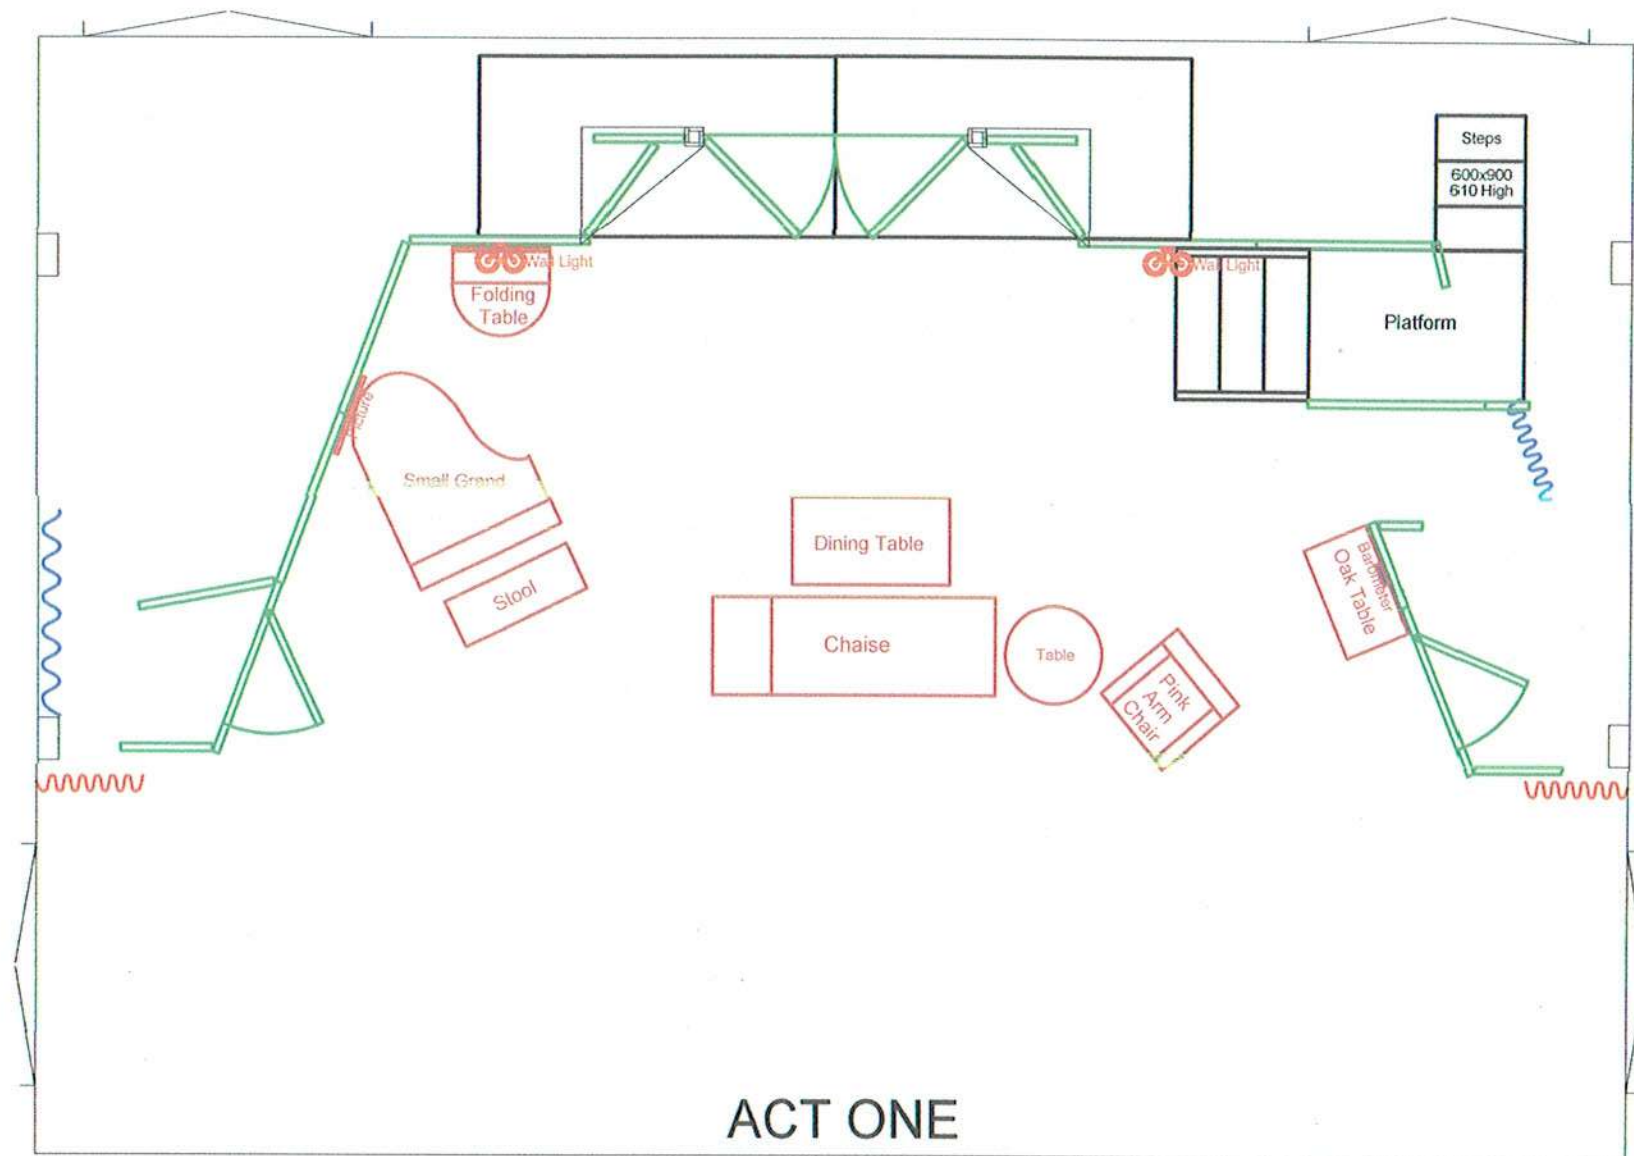

Event

HAY FEVER

Director

Julian Harrison

Producer

Company Theatre Inc.

Set Design

Ian Birch

Performance

8-22 August 2015

Lighting Design

Scott Thomas

Venue


Rose Centre

Date

22.06.15

Rev

0.7

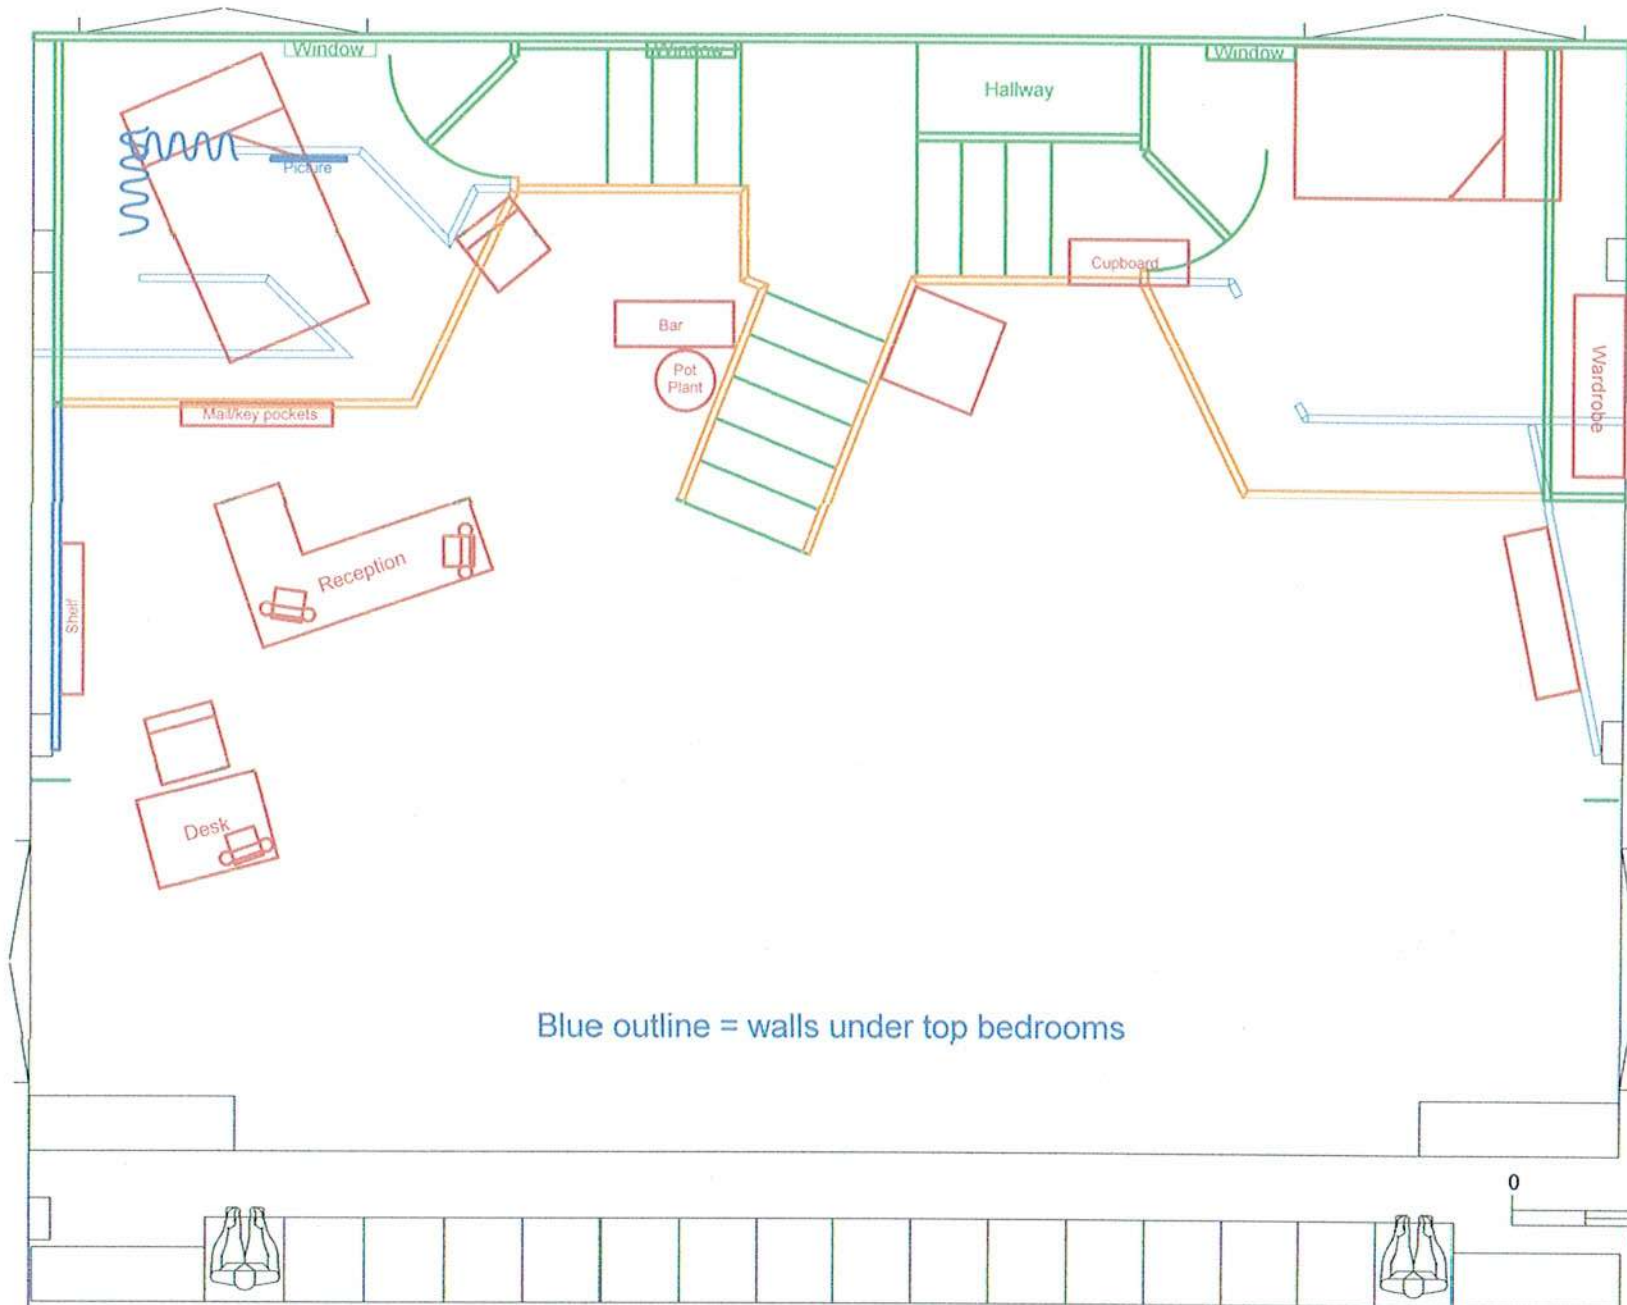

Event

MORE FAWLTY TOWERS

Drawing

Producer

Company Theatre

Lighting Design

Scott Thomas

Director

Kathy Gent

Set Design

Phil Davis

Performance

15-29 Nov 2014

Venue


The Rose Centre

Date

26/09/14

Rev

0.6

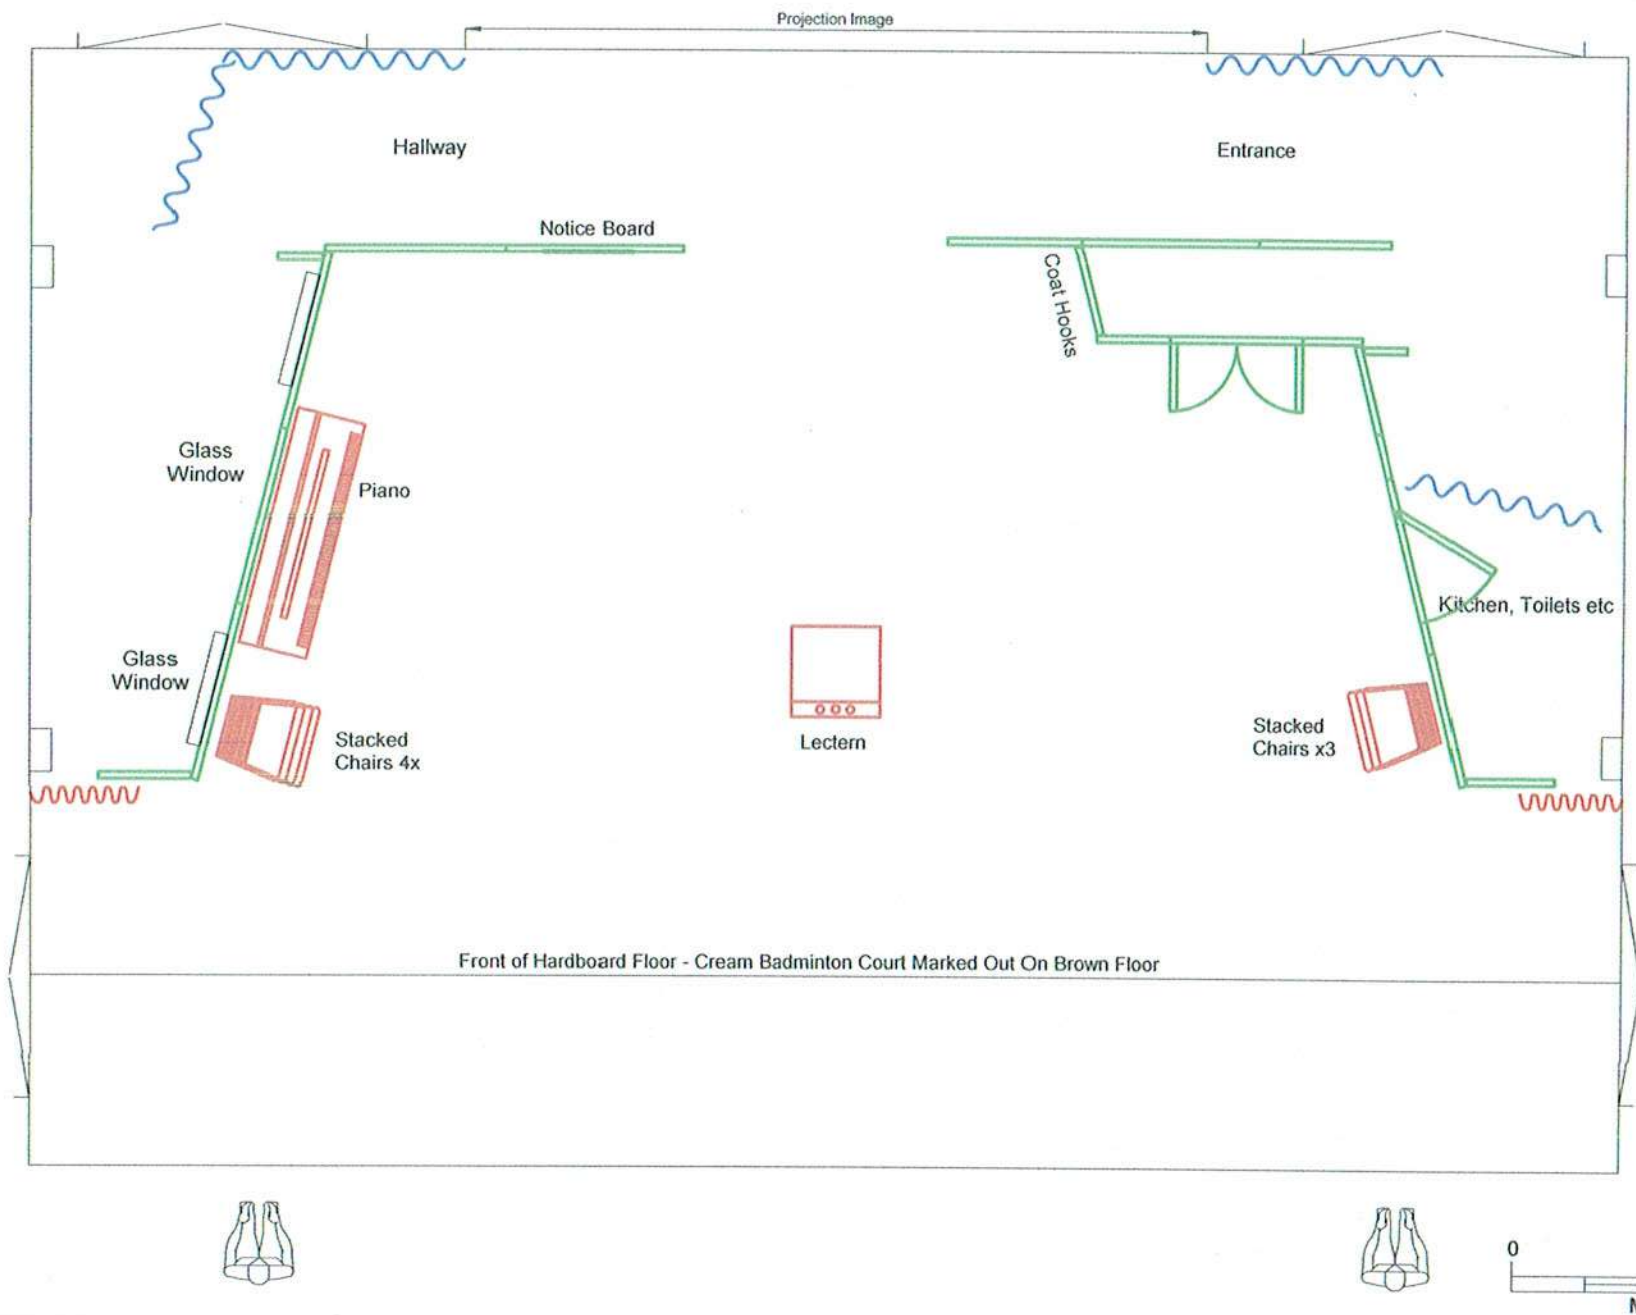

Event

Calendar Girls

Director

Kathy Gent

Producer

Company Theatre Inc.

Set Design

Anne Rimmer

Performance

6-27 April 2013

Lighting Design

Scott Thomas

Venue

 

Rose Centre

Date

27.01.13

Rev

1.2

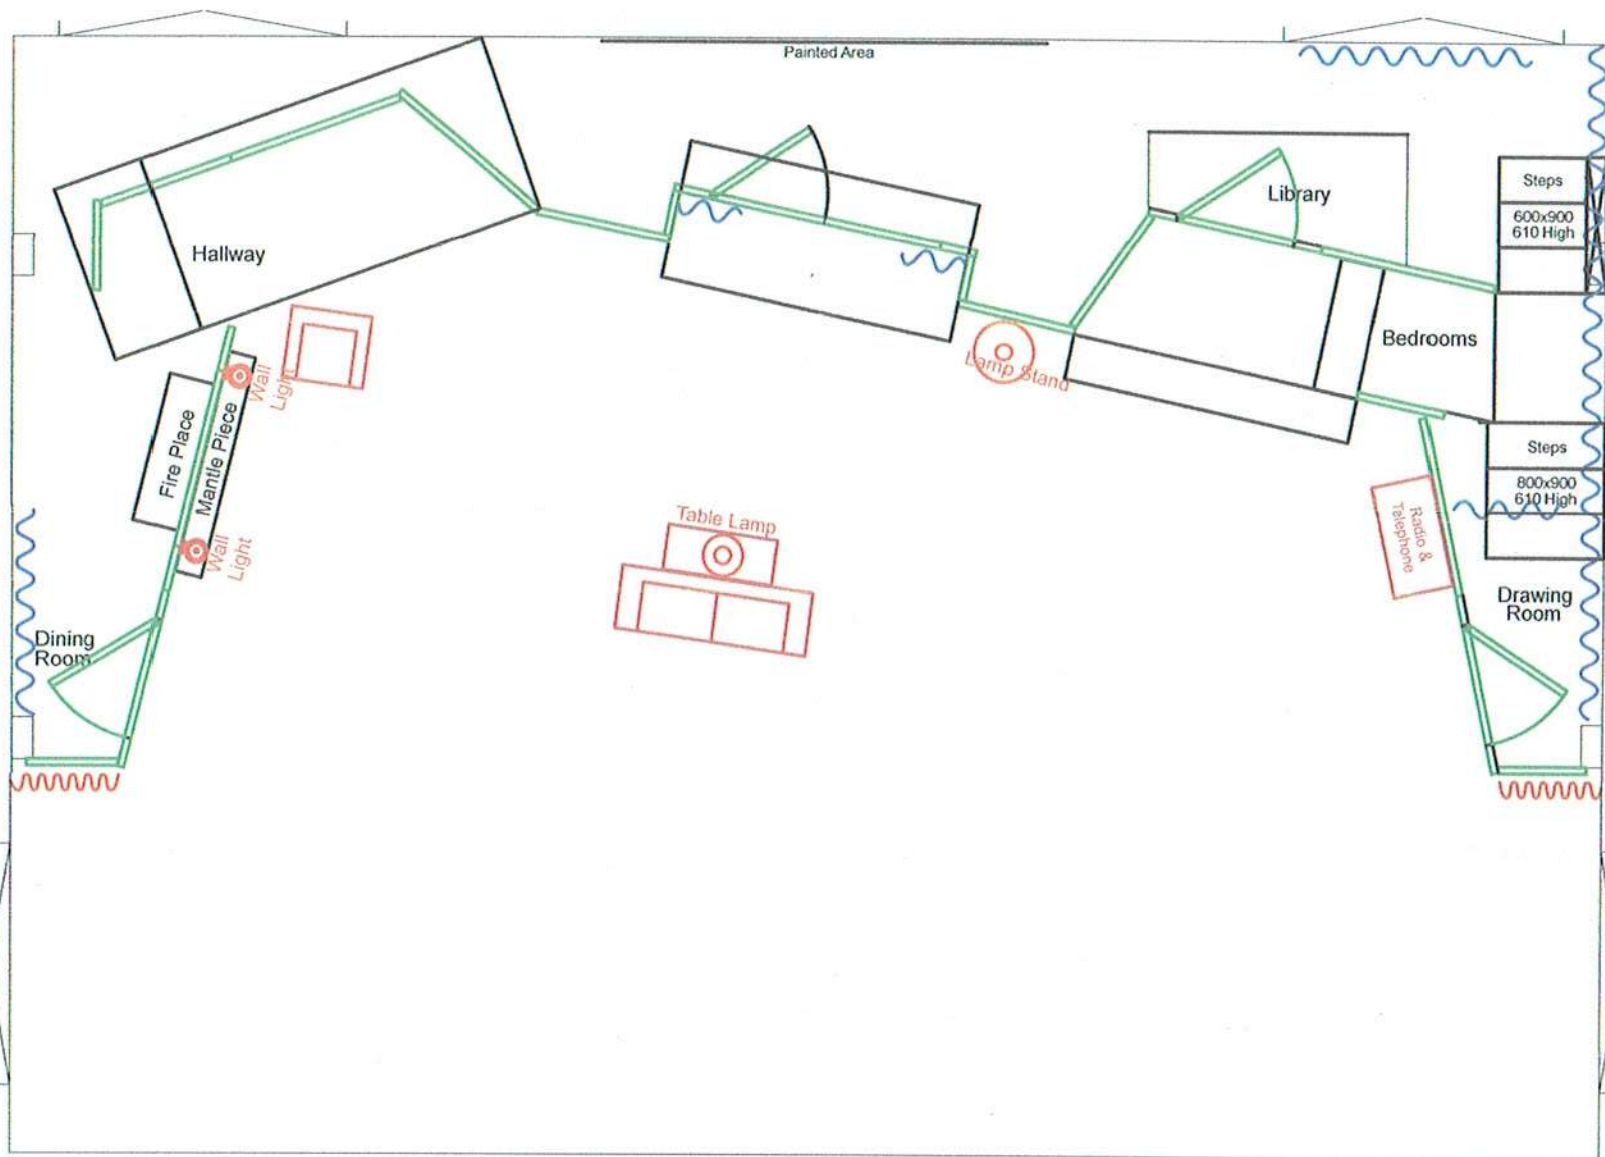

Event

THE MOUSETRAP

Director
Sian Davis

Producer
Company Theatre Inc.

Set Design
Janet Williamson


Performance
9-24 November 2012

Lighting Design
Scott Thomas

Venue
Rose Centre

Date
03.09.12

Rev
1.1

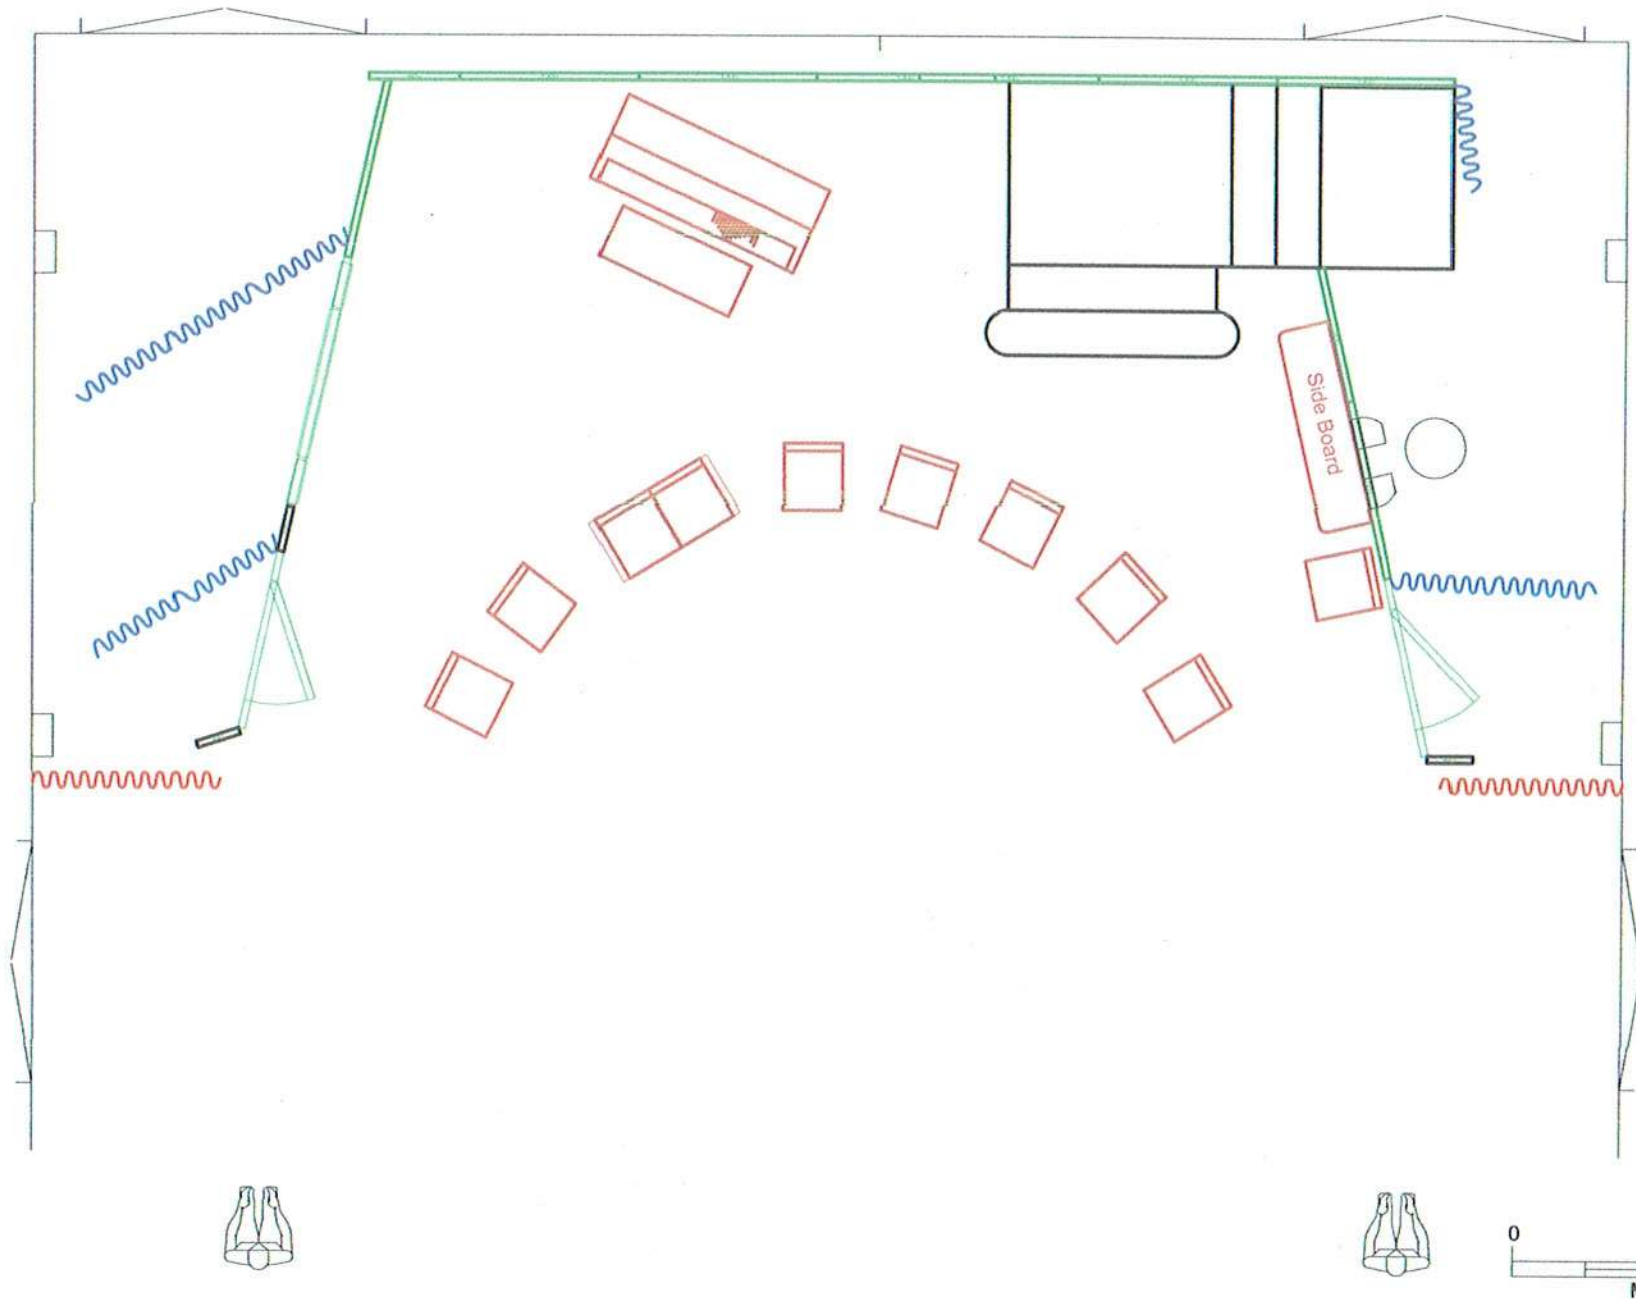

Event

Improbable Fiction

Drawing

Director

Performance

Date

Producer

Company Theatre Inc.


Lighting Design

Scott Thomas

Venue

Rose Centre

Rev

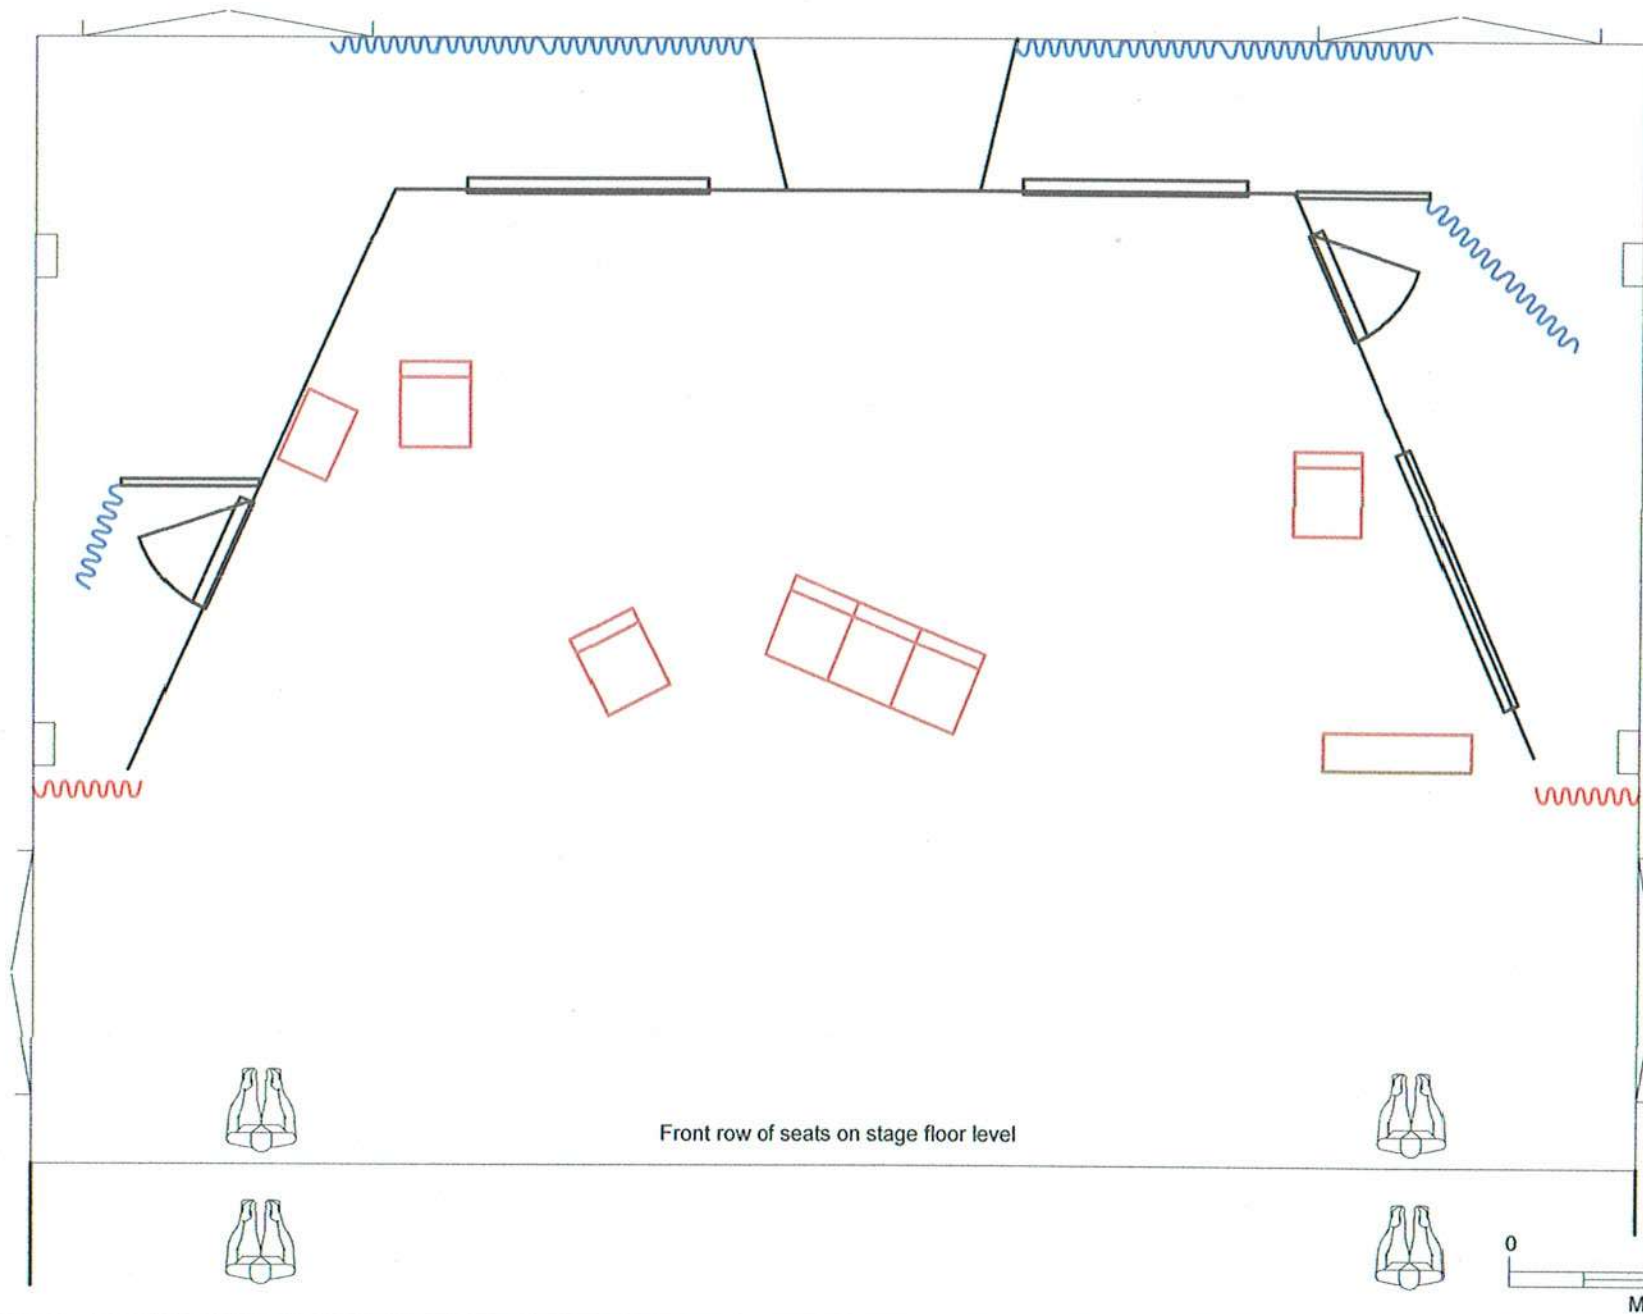

Event

Pride & Prejudice

Producer

Company Theatre Inc.

Venue

Rose Centre Theatre

Director

Karl Buckley

Lighting Design

Scott Thomas

Drawing

Set Floor Plan

Set Design

Phil

Performance

26th to 9th April 2011

Scale

A4 Scale 50:1

Rev

2



Event

Who Wants To Be 100

Drawing

Producer

Company Theatre Inc.

Director

Sian Davis

Lighting Design

Scott Thomas

Performance

13-27 March 2010

Venue


Rose Centre

Date

13.01.10

Rev

2.1

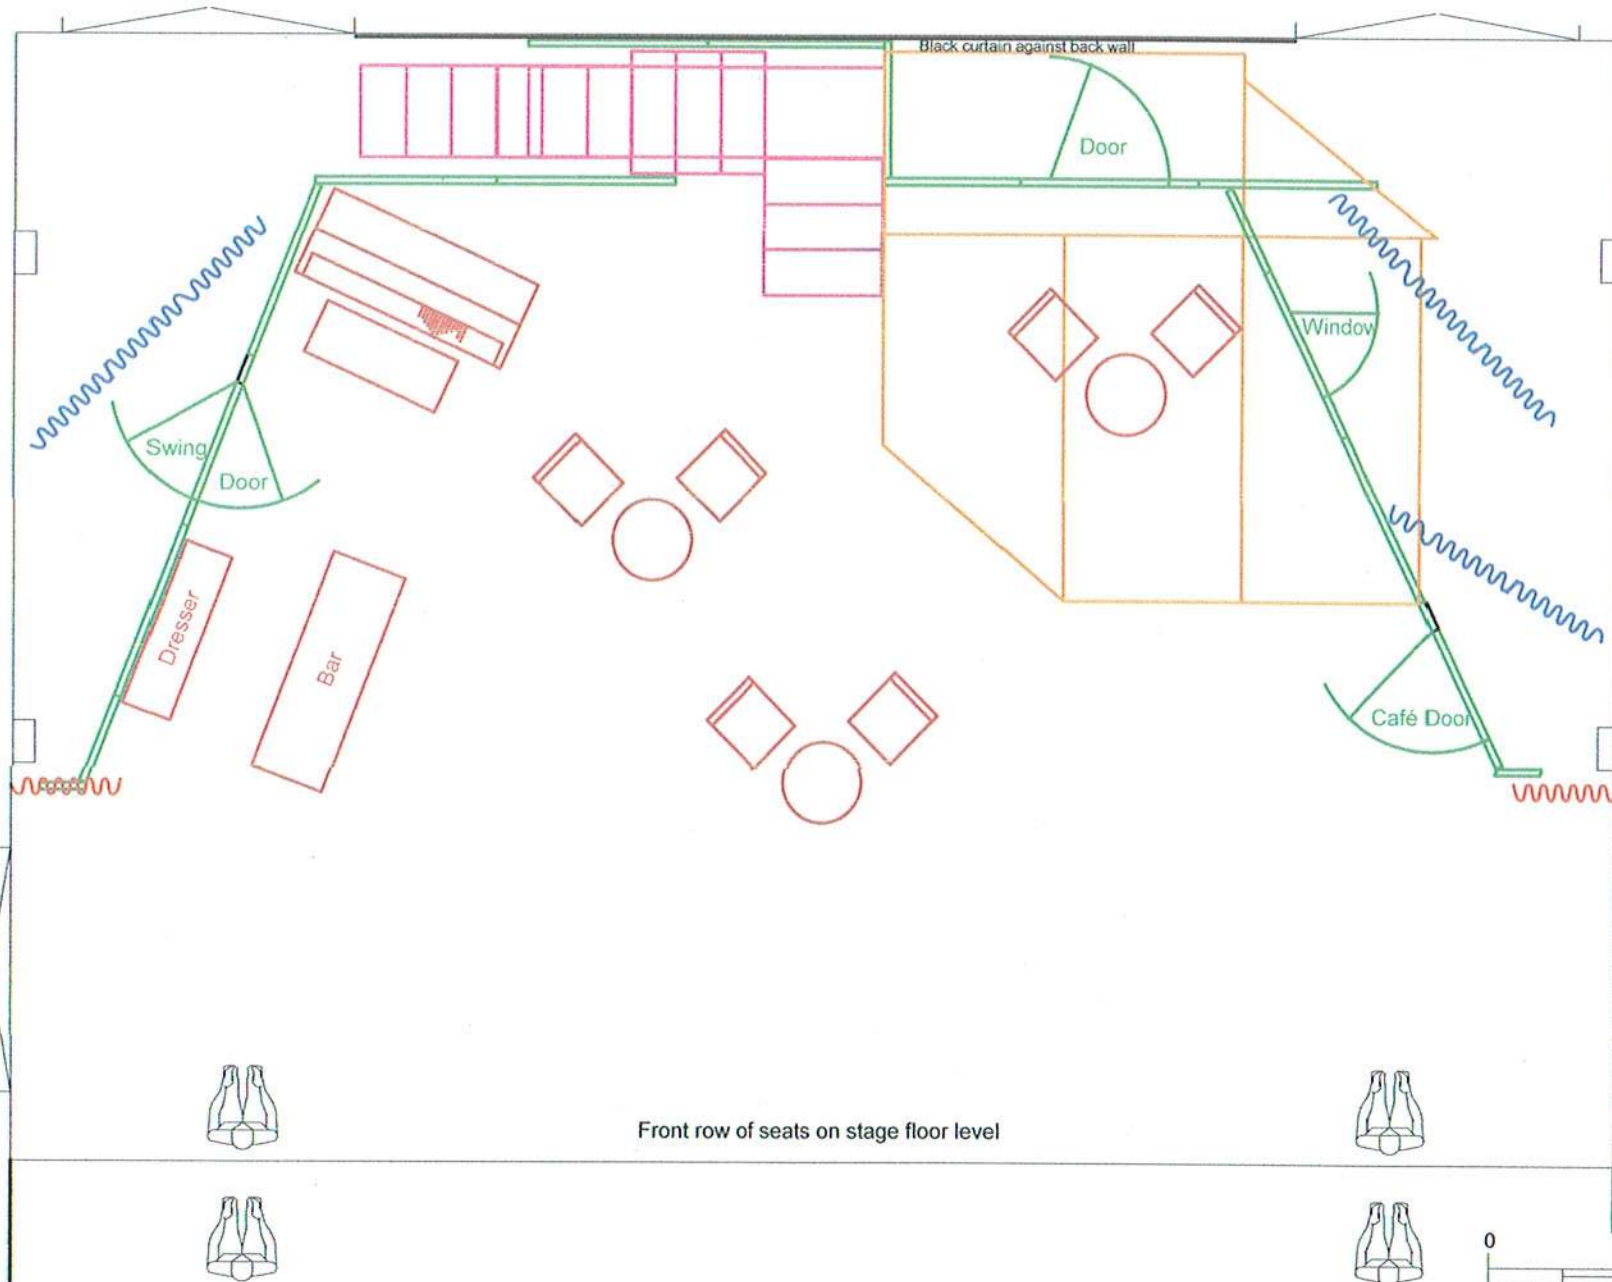

Event

'Allo 'Allo

Producer

Company Theatre Inc.

Venue

Rose Centre Theatre

Director

Kathy Gent

Lighting Design

Scott Thomas

Drawing

Set Floor Plan

Set Design

Caroline Parker

Performance


8th - 23rd August 2008

Scale

A4 Scale 50:1

Rev

2

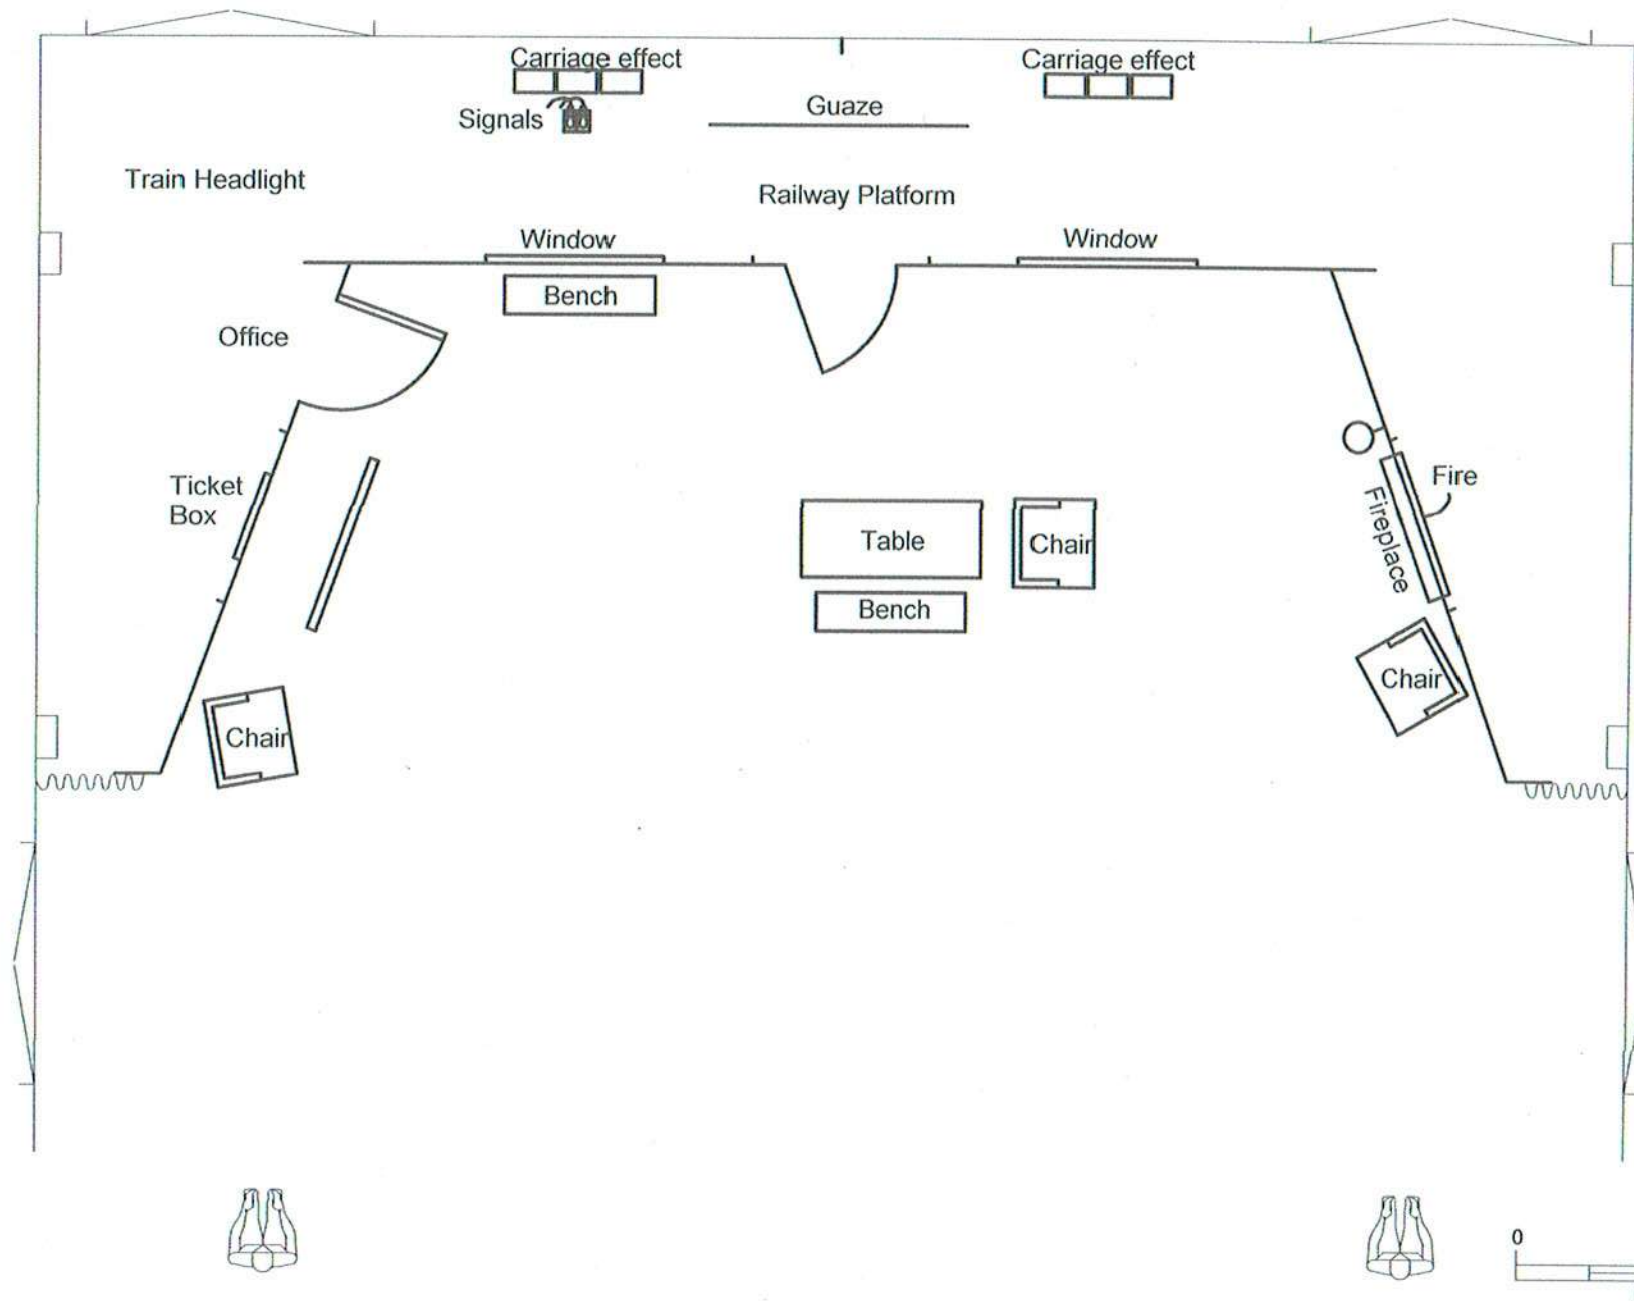

Event

The Ghost Train

Drawing

Producer

Company Theatre Inc.

Director

Kathy Gent

Lighting Design

Scott Thomas

Performance

20 Mar - 3 Apr 2004

Venue


Rose Centre

Date

01.02.04

Rev

1

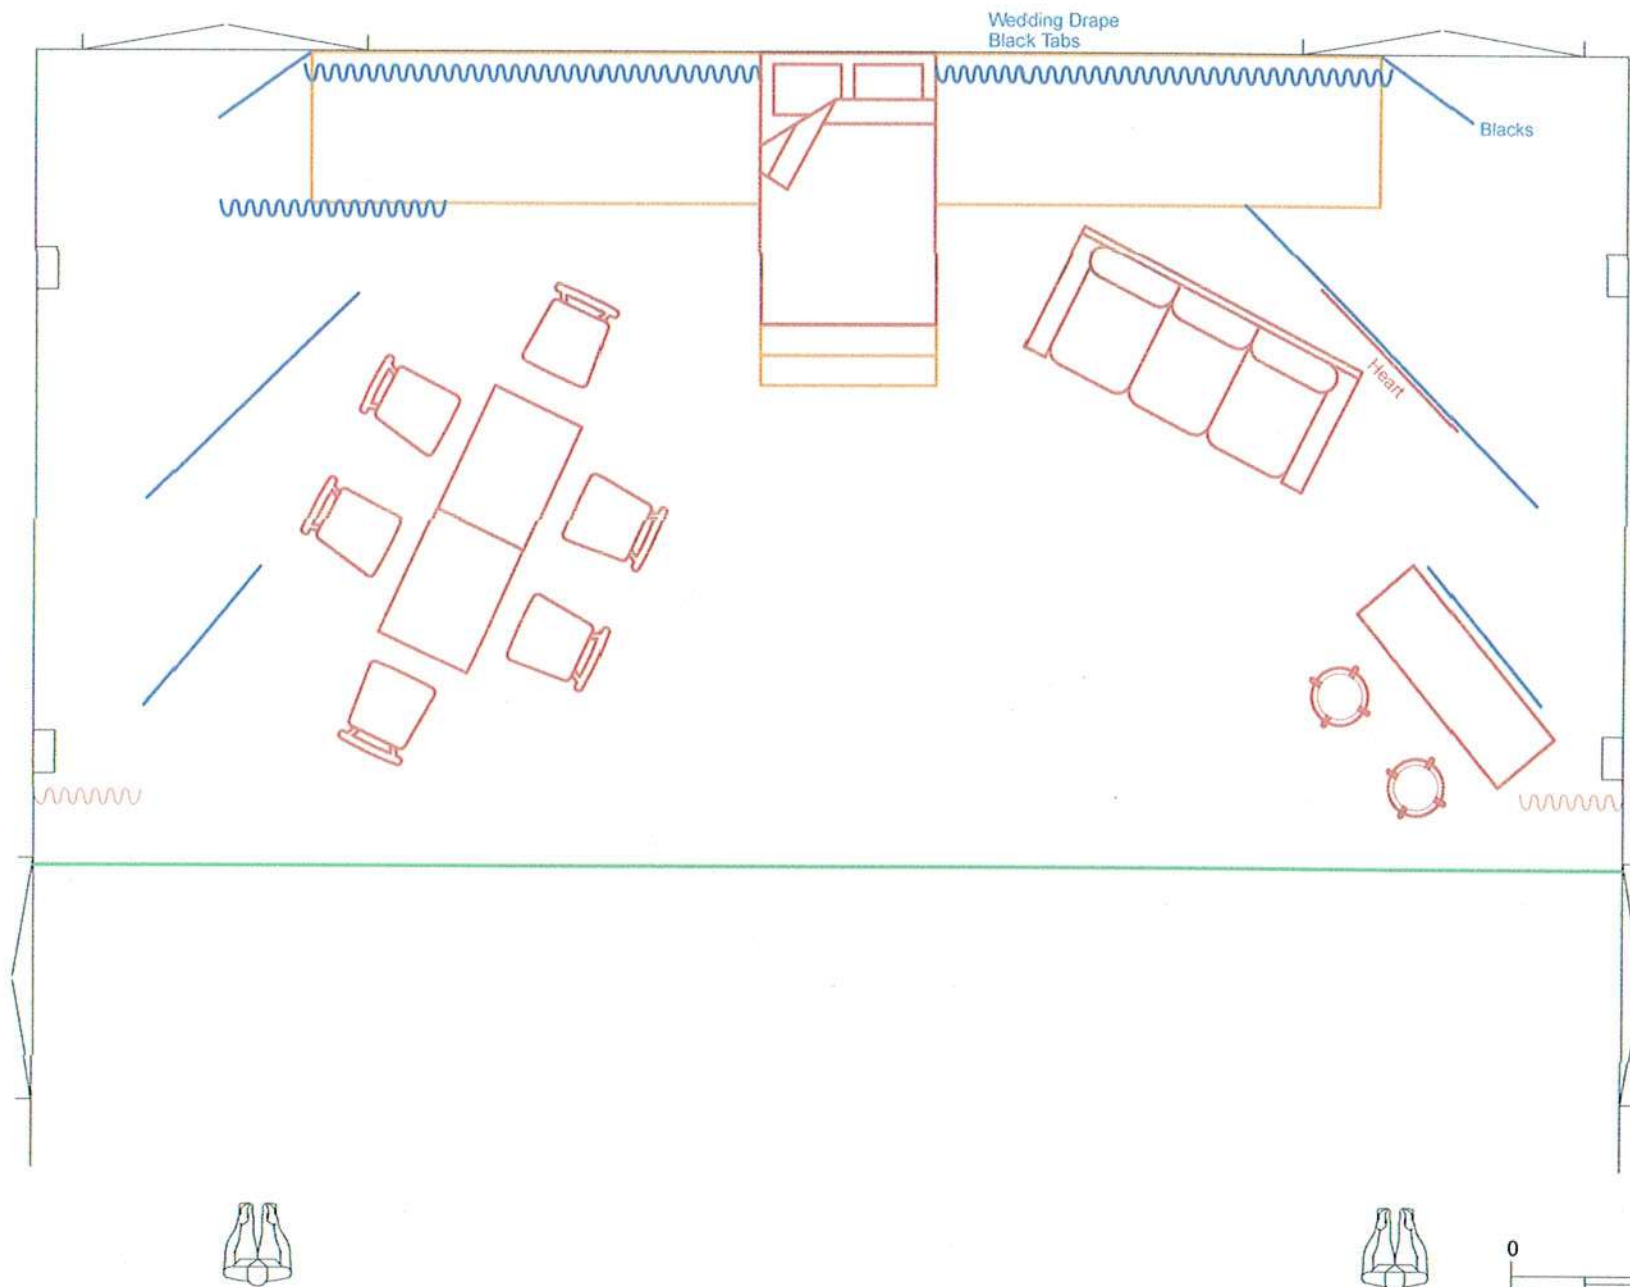

Event

Take a Chance on Me

Drawing

Producer

Company Theatre Inc.

Director

Kathy Gent

Lighting Design

Scott Thomas

Performance

20 Mar - 3 Apr 2004

Venue

Rose Centre

Date

01.02.04

Rev

1